


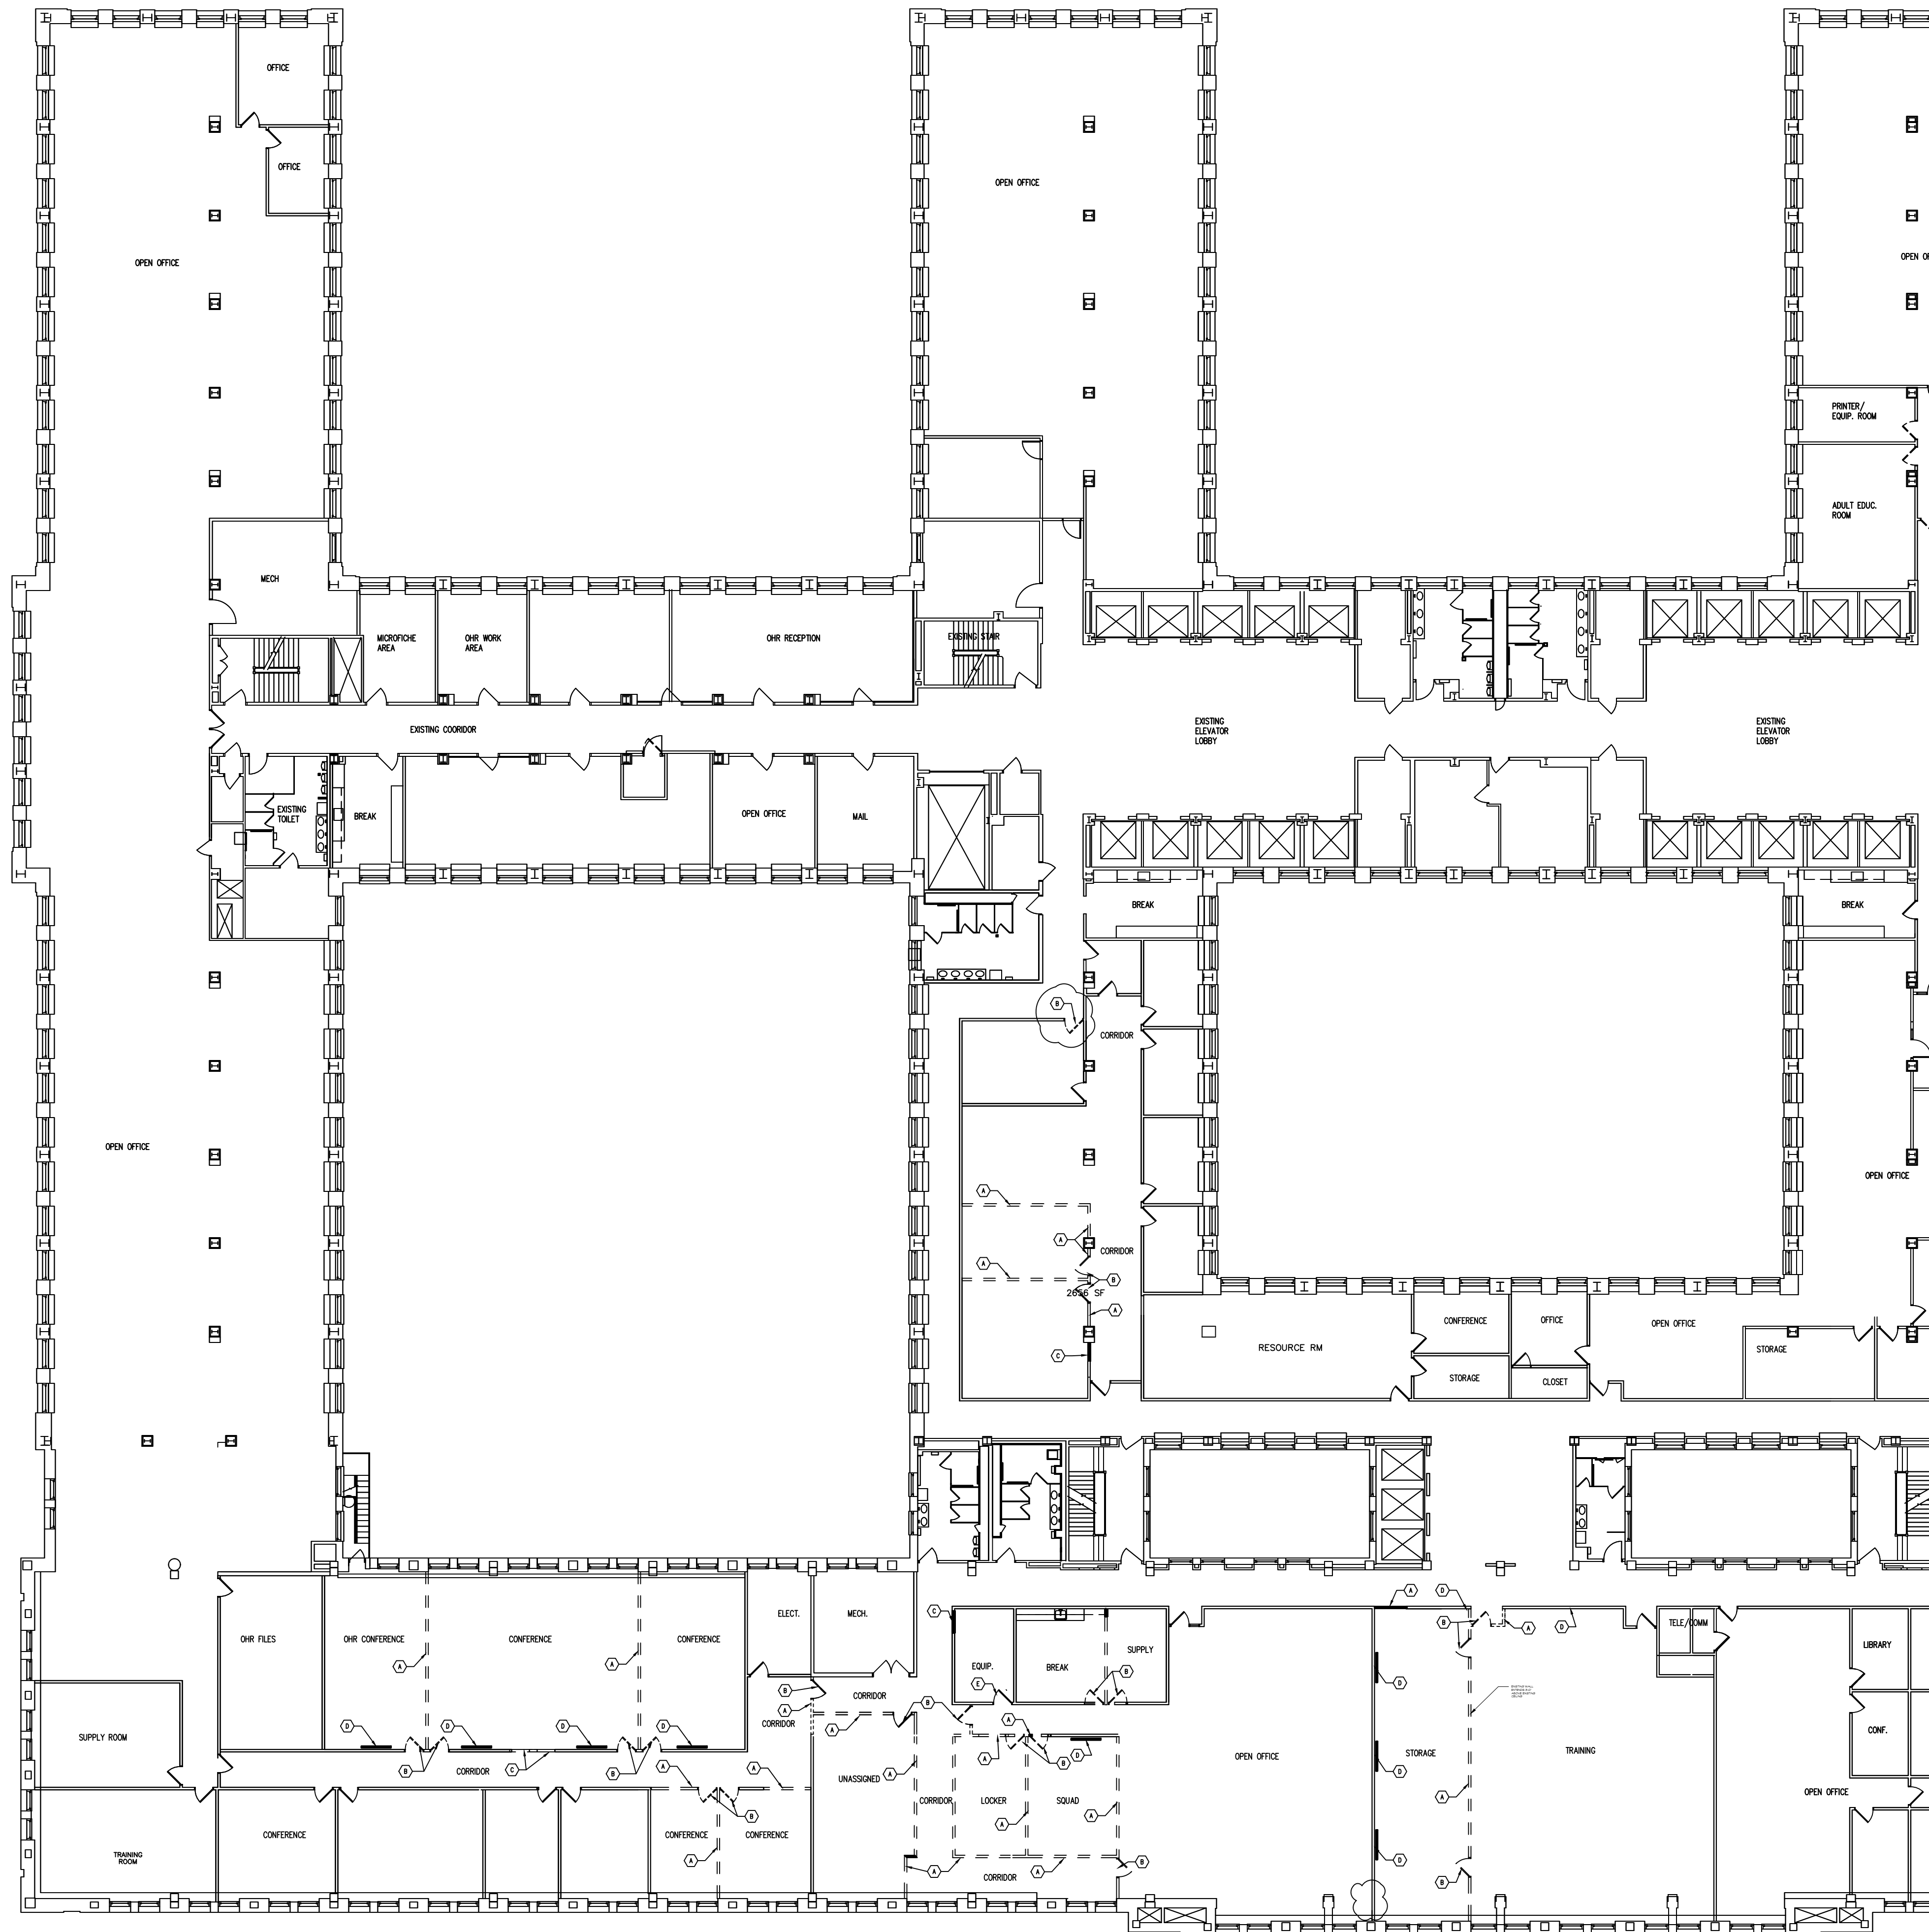

KEY NOTES - DEMOLITION :

- (A) REMOVE EXISTING WALLS & ALL ASSOCIATED COMPONENTS INCLUDING HEADERS, FLOOR & WALL ANCHORS, ETC TO ALLOW FOR PROPER INSTALLATION OF NEW FINISHES, DOOR OPENINGS W/ HEADERS, ETC. REMOVE & GRIND DOWN ALL CHANNEL ANCHORS IN FASTENERS.
- (B) REMOVE EXISTING DOOR & FRAME REMOVE ALL EXISTING DOOR & FRAME COMPONENTS
- (C) CUT NEW OPENING IN EXISTING WALL FOR NEW DOOR & FRAME.
- (D) CUT OPENING IN WALL AS NEEDED FOR INSTALLATION OF NEW FIRE-TREATED WOOD BLOCKING IN WALL FOR NEW MONITOR HANGER. PATCH EXISTING DRYWALL TO MATCH WITHOUT A NOTICEABLE PATCHED APPEARANCE.
- (E) REMOVE EXISTING DOOR LEVER & HARDWARE ONLY FOR NEW OCCUPIED/UNOCCUPIED DOOR HARDWARE. SEE HARDWARE SCHEDULE.

GENERAL NOTES :

1. VERIFY ALL EXISTING CONDITIONS REPORT ANY DISCREPANCIES IN WRITING TO ARCHITECT & OWNER REPRESENTATIVE.
2. PROVIDE ALL NECESSARY TEMPORARY SHORING & SUPPORTS AS REQUIRED TO COMPLETE THE INDICATED WORK'S INTENT.
3. PROVIDE ALL NECESSARY TEMPORARY PARTITIONS & BARRIERS TO CONTAIN & MINIMIZE DUST.
4. REMOVE ALL DIAGONAL BRACINGS ABOVE CEILING AT DEMOLISHED WALLS AS REQUIRED.
5. MAINTAIN FIRE EGRESS TO EXITS DURING WORK.
6. SEE MECHANICAL, PLUMBING, & ELECTRICAL PLANS (MEP) FOR ADDITIONAL DEMOLITION WORK.

ADDENDUM NO. 1 05-15-2025
ISSUED FOR BIDS 04-25-2025
50% PHASE 500 02-12-2025


DEPT. OF HEALTH & HUMAN
SERVICES
CADILLAC PLACE 4TH FLOOR
ANNEX TRAINING SUITE
BUILD-OUT

FILE NO: 491_24304_MNB

CADILLAC PLACE
3044 W. GRAND BLVD
DETROIT, MICHIGAN 48202

2434

STATE OF MICHIGAN
DEPARTMENT OF TECHNOLOGY, MANAGEMENT AND BUDGET
STATE FACILITIES ADMINISTRATION
DESIGN AND CONSTRUCTION DIVISION
ADAM P. LACH, RA, DIRECTOR

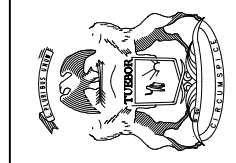

**Straub
Pettitt
Yaste**

850 NORTH CROSS ROAD
SUITE 200
CLARKSVILLE, MICHIGAN 48017-1311


248-658-7777 PHONE
248-658-7761 FAX




PARTIAL 4TH FLOOR PLAN- DEMOLITION
SCALE 1/16" = 1'-0"

0 8' 16' 32'
SCALE: 1/16" = 1'-0"

DEMO PLAN

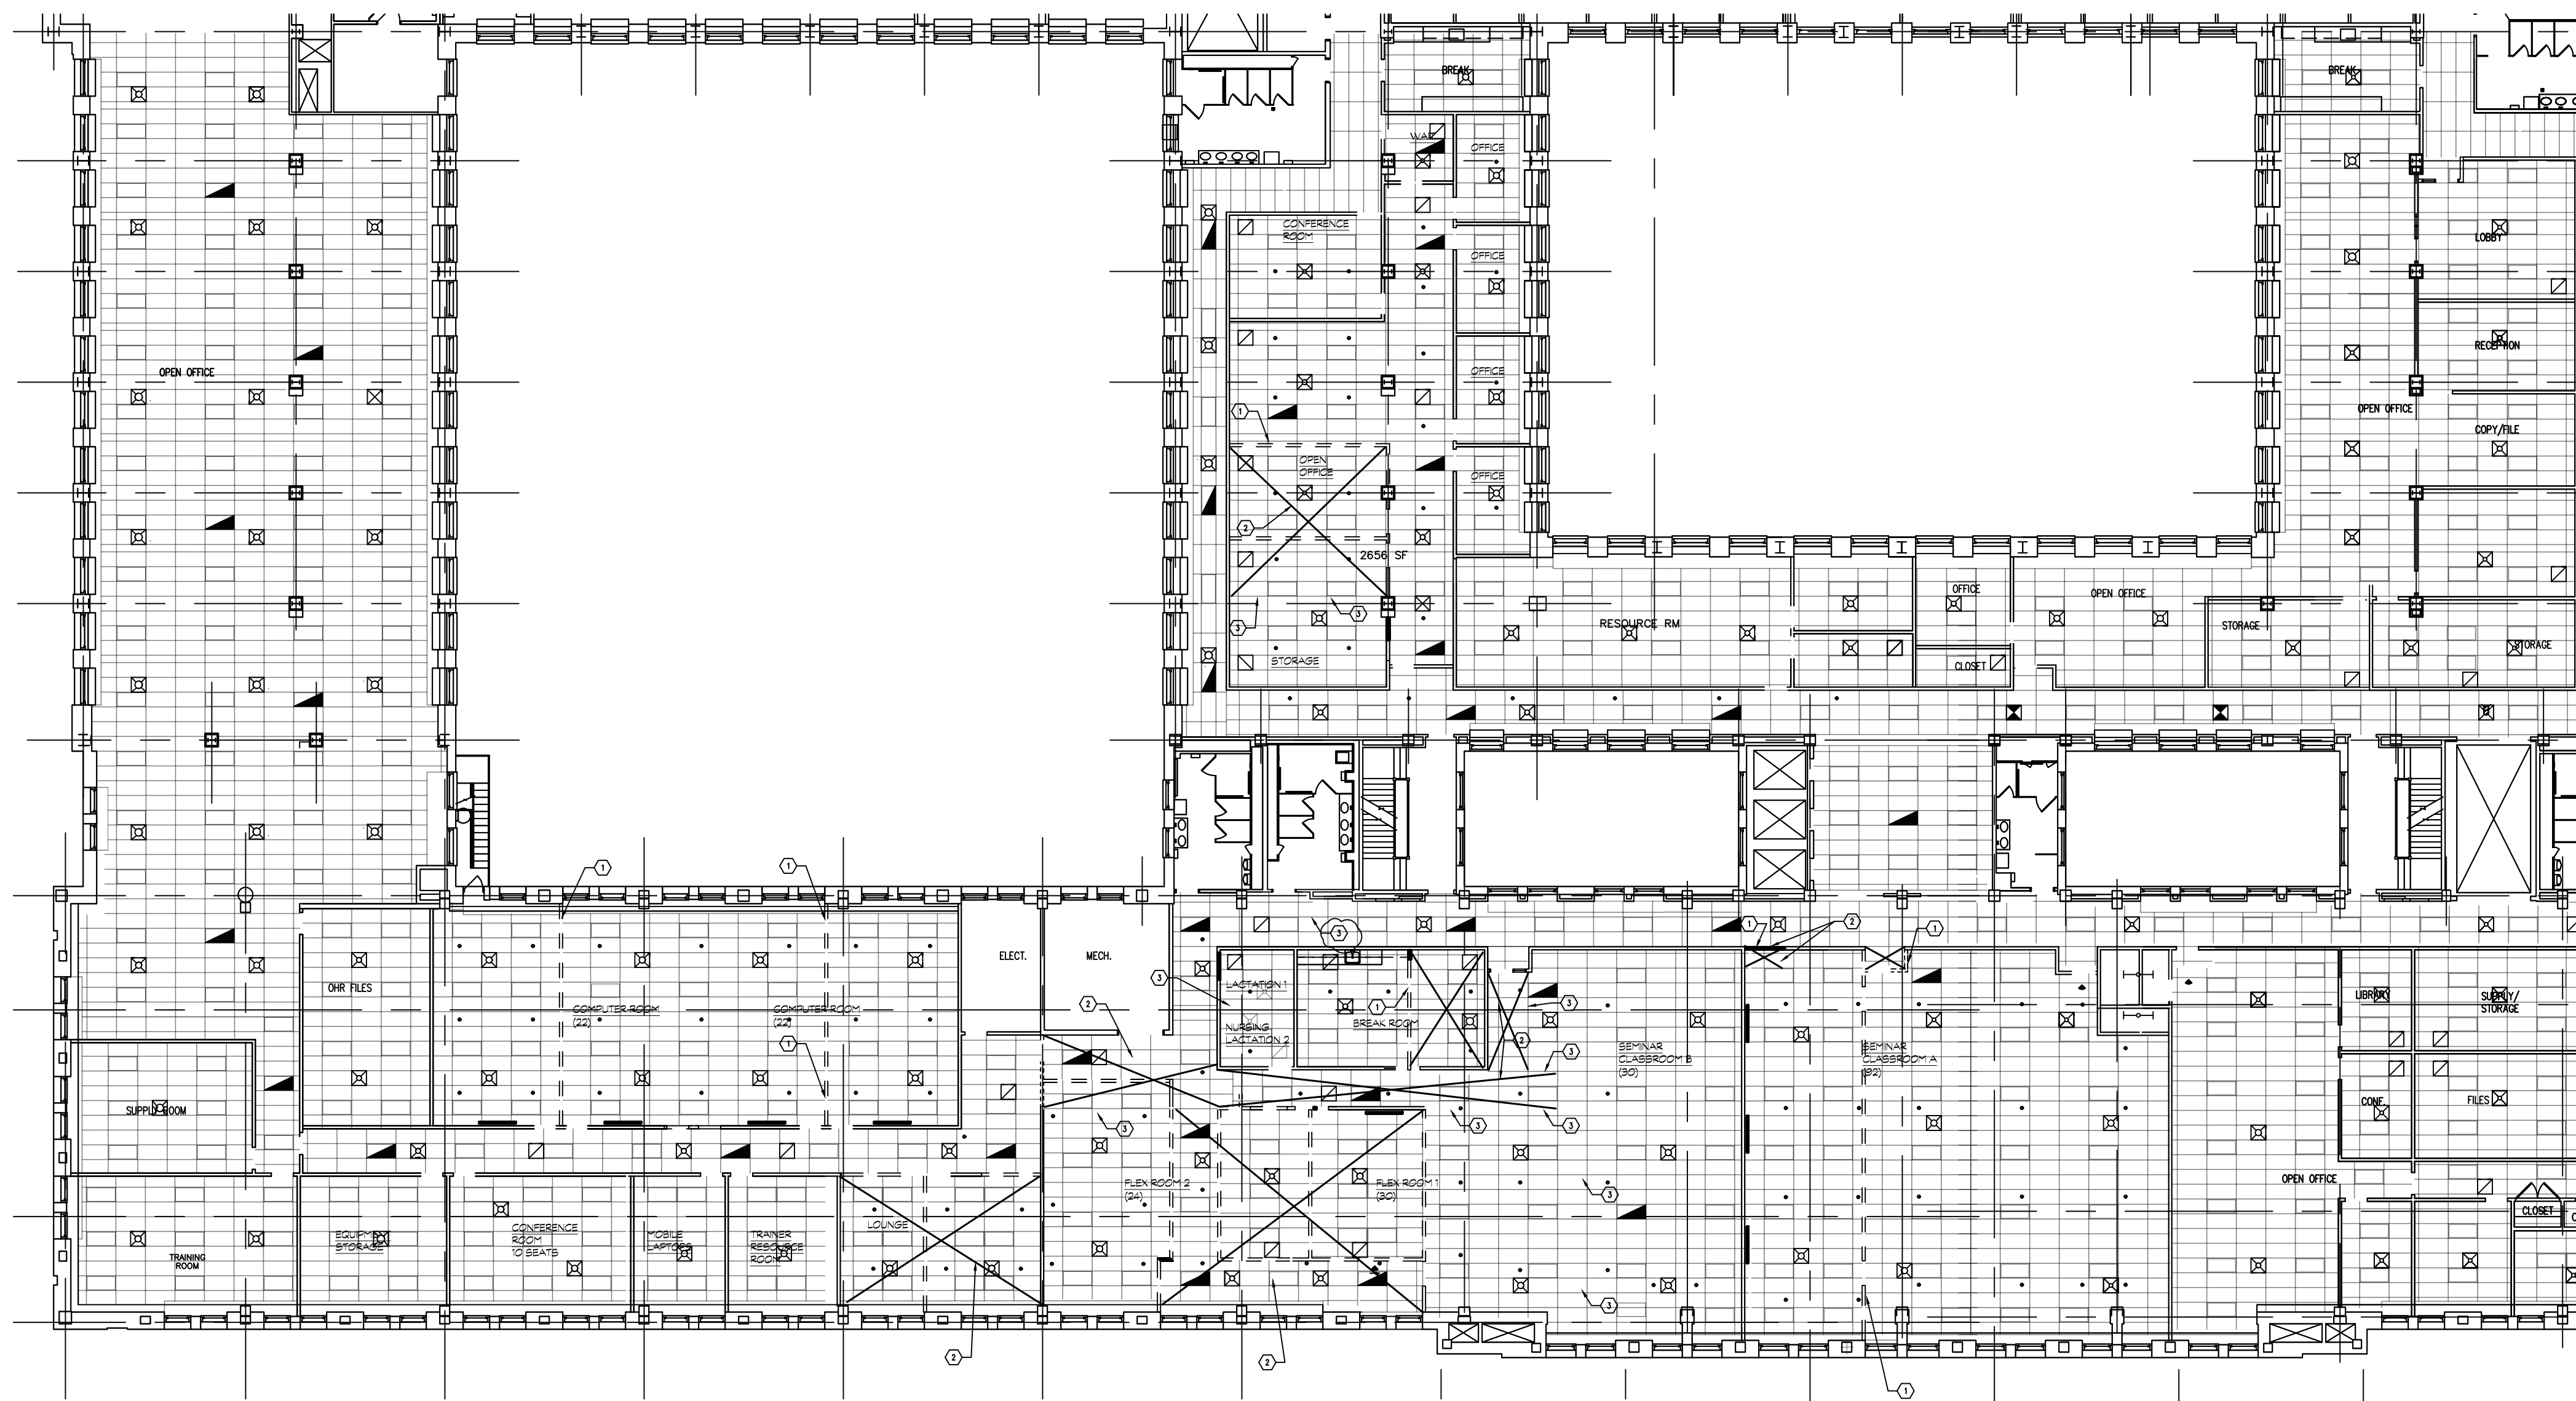



PARTIAL 4TH FLOOR REFLECTED CEILING PLAN DEMO
SCALE: 1/16" = 1'-0"

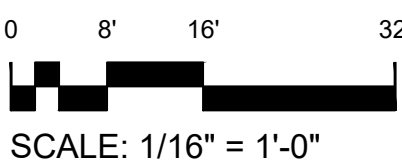

GENERAL NOTE:

DRAWINGS HAVE BEEN COMPLETED FROM INFORMATION PROVIDED BY OTHERS. STRAUB PETTITT YASTE (S.P.Y.) HAS NOT VERIFIED THE ACCURACY AND/OR THE COMPLETENESS OF THIS INFORMATION AND SHALL NOT BE RESPONSIBLE FOR ANY ERRORS OR OMISSIONS WHICH MAY BE INDICATED AS A RESULT. VERIFY ALL CONDITIONS PRIOR TO ANY CONSTRUCTION AND REPORT ANY DISCREPANCIES IN WRITING IMMEDIATELY TO STRAUB PETTITT YASTE ARCHITECTS & THE OWNER'S REPRESENTATIVE OF THIS PROJECT.

  LEGEND :


-  2 X 4' LIGHT FIXTURE, SEE ELECTRICAL
-  2 X 4' ACOUSTIC LAY-IN CEILING IN 2 X 4' SUSPENDED METAL CEILING GRID SYSTEM, NEW ACOUSTICAL CEILING PANELS TO MATCH EXISTING.
-  RETURN AIR GRILLE
-  SUPPLY AIR DIFFUSER
-  FIRE SPRINKLER HEAD

KEY NOTES - DEMOLITION :

- ① REMOVE EXISTING CEILING PANELS & GRID ONLY AS NEEDED TO REMOVE EXISTING WALL, PATCH AND REINSTALL GRID SYSTEM, INSTALL CEILING PANELS.
- ② REMOVE EXISTING CEILING PANELS & GRID, REINSTALL / INSTALL GRID SYSTEM TO ALIGN WITH CEILING GRID IN NEIGHBORING ROOM.
- ③ REMOVE PORTION OF EXISTING CEILING GRID AND PANELS FOR INSTALLATION OF NEW WALL, PATCH AND REINSTALL GRID SYSTEM, INSTALL CEILING PANELS. SEE SHEET A1 FOR NEW WALLS.

GENERAL NOTES :

1. VERIFY ALL EXISTING CONDITIONS REPORT ANY DISCREPANCIES IN WRITING TO ARCHITECT & OWNER REPRESENTATIVE.
2. PROVIDE ALL NECESSARY TEMPORARY SHORING & SUPPORTS AS REQUIRED TO COMPLETE THE INDICATED WORK'S INTENT.
3. PROVIDE ALL NECESSARY TEMPORARY PARTITIONS & BARRIERS TO CONTAIN & MINIMIZE DUST.
4. REMOVE ALL DIAGONAL BRACING ABOVE CEILING AT DEMOLISHED WALLS AS REQUIRED.
5. MAINTAIN FIRE EGRESS TO EXITS DURING WORK.
6. SEE MECHANICAL PLUMBING & ELECTRICAL FOR MEP WORK.

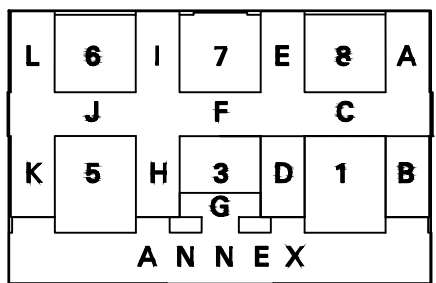

ADDENDUM NO 1 05-15-2025
ISSUED FOR BIDS 04-29-2025
50% PHASE 500 02-12-2025


DEPT. OF HEALTH & HUMAN
SERVICES
CADILLAC PLACE 4TH FLOOR
OWDT TRAINING SUITE
BUILD-OUT

FILE NO: 491_24304_MNB

CADILLAC PLACE
3044 W. GRAND BLVD
DETROIT, MICHIGAN 48202

2434

STATE OF MICHIGAN
DEPARTMENT OF TECHNOLOGY, MANAGEMENT AND BUDGET
STATE FACILITIES ADMINISTRATION
DESIGN AND CONSTRUCTION DIVISION
ADAM P. LACH, RA, DIRECTOR

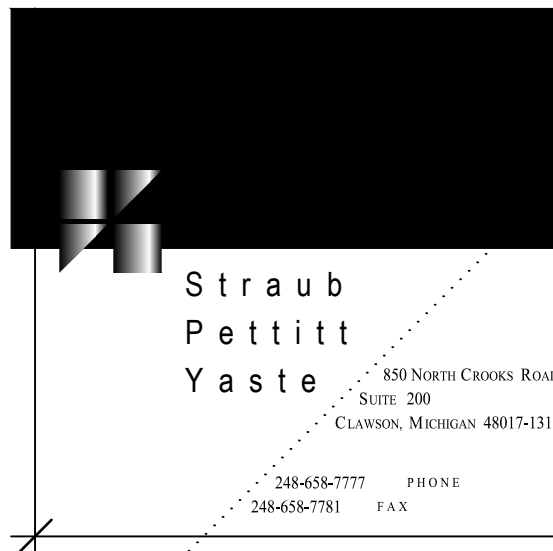

REFLECTED CEILING
PLAN DEMOLITION

0 8' 16' 3'




SCALE: 1/16" = 1'-0"


Diagram illustrating three types of door and window frames:

- TYPE A (FRAME TYPE):** Shows a frame with dimensions 2" for the top, bottom, and side rails. A note "SEE SCHEDULE" is present.
- TYPE 1 (FLUSH PANEL DOOR):** Shows a flush panel door.
- TYPE 2 (DOOR TYPES):** Shows a door with a 6" top rail, 8" bottom rail, and 10" side rail. A note "SEE SCHEDULE" is present, and the text "GLAZING TYPE" is also shown.

- ① NEW WALL SEE WALL DETAIL NO 1 THIS SHEET
- ② NEW HOLLOW METAL DOOR IN HOLLOW METAL FRAME. SEE DOOR SCHEDULE
- ③ PATCH WALL & PAINT
- ④ DELETE SOUND ATTENUATION BLANKET IN NEW WALL
- ⑤ LOCATION OF NEW WALL MOUNTED MONITOR. OPEN WALL AS NEEDED AND INSTALL SOLID FIRE-TREATED WOOD BLOCKING BETWEEN STUDS.

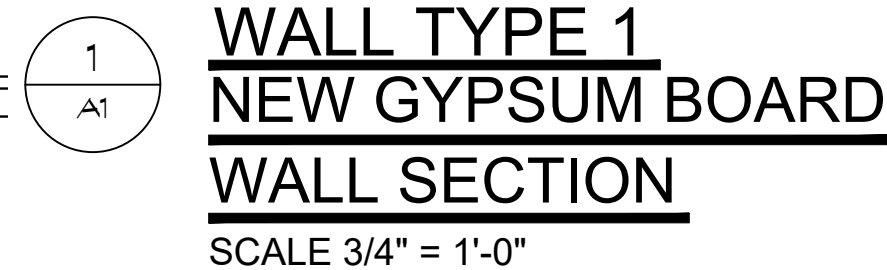

1. VERIFY ALL EXISTING CONDITIONS REPORT ANY DISCREPANCIES IN WRITING TO ARCHITECT & OWNER REPRESENTATIVE.
2. PROVIDE ALL NECESSARY TEMPORARY SHORING & SUPPORTS AS REQUIRED TO COMPLETE THE INDICATED WORKS IN TENT.
3. PATCH FLOORS, WALLS, & CEILINGS TO MATCH ADJACENT SURFACES AFFECTED BY DEMOLISHED CEILINGS, WALLS, DOORS & FRAMES. ALSO SEE DEMO PLAN.
4. PROVIDE ALL NECESSARY TEMPORARY PARTITIONS & BARRIERS TO CONTAIN & MINIMIZE DUST.
5. MAINTAIN FIRE EGRESS TO EXITS DURING WORK.
6. PAINT ALL CORRIDOR WALLS IN COMMON WITH THE SHADED ROOM SPACES OF THE RENOVATED AREAS
7. SEE MECHANICAL, PLUMBING, & ELECTRICAL PLANS (MEP) FOR ADDITIONAL NEW WORK.
8. THERE ARE SEVEN 8" DIAMETER HOLES DRILLED IN VARIOUS WALLS IN ORDER TO CHECK FOR INSULATION. THESE HOLES IN WALLS, WHICH ARE TO REMAIN, ARE TO BE PATCHED.

 


CADILLAC PLACE
3044 W. GRAND BLVD
DETROIT, MICHIGAN 48202
2434



**Straub
Pettitt
Yaste**

850 NORTH CROOKS ROAD
SUITE 200
CLAWSON, MICHIGAN 48017-1311


248-658-7777 PHONE
248-636-7781 FAX

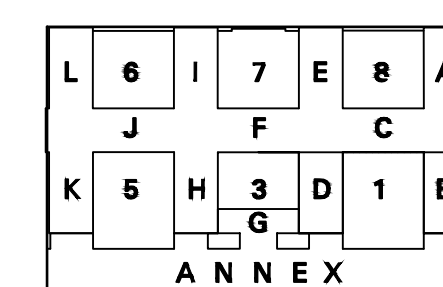

FLOOR PLAN
WALL SECTION
SCHEDULES

KEY PLAN

A1

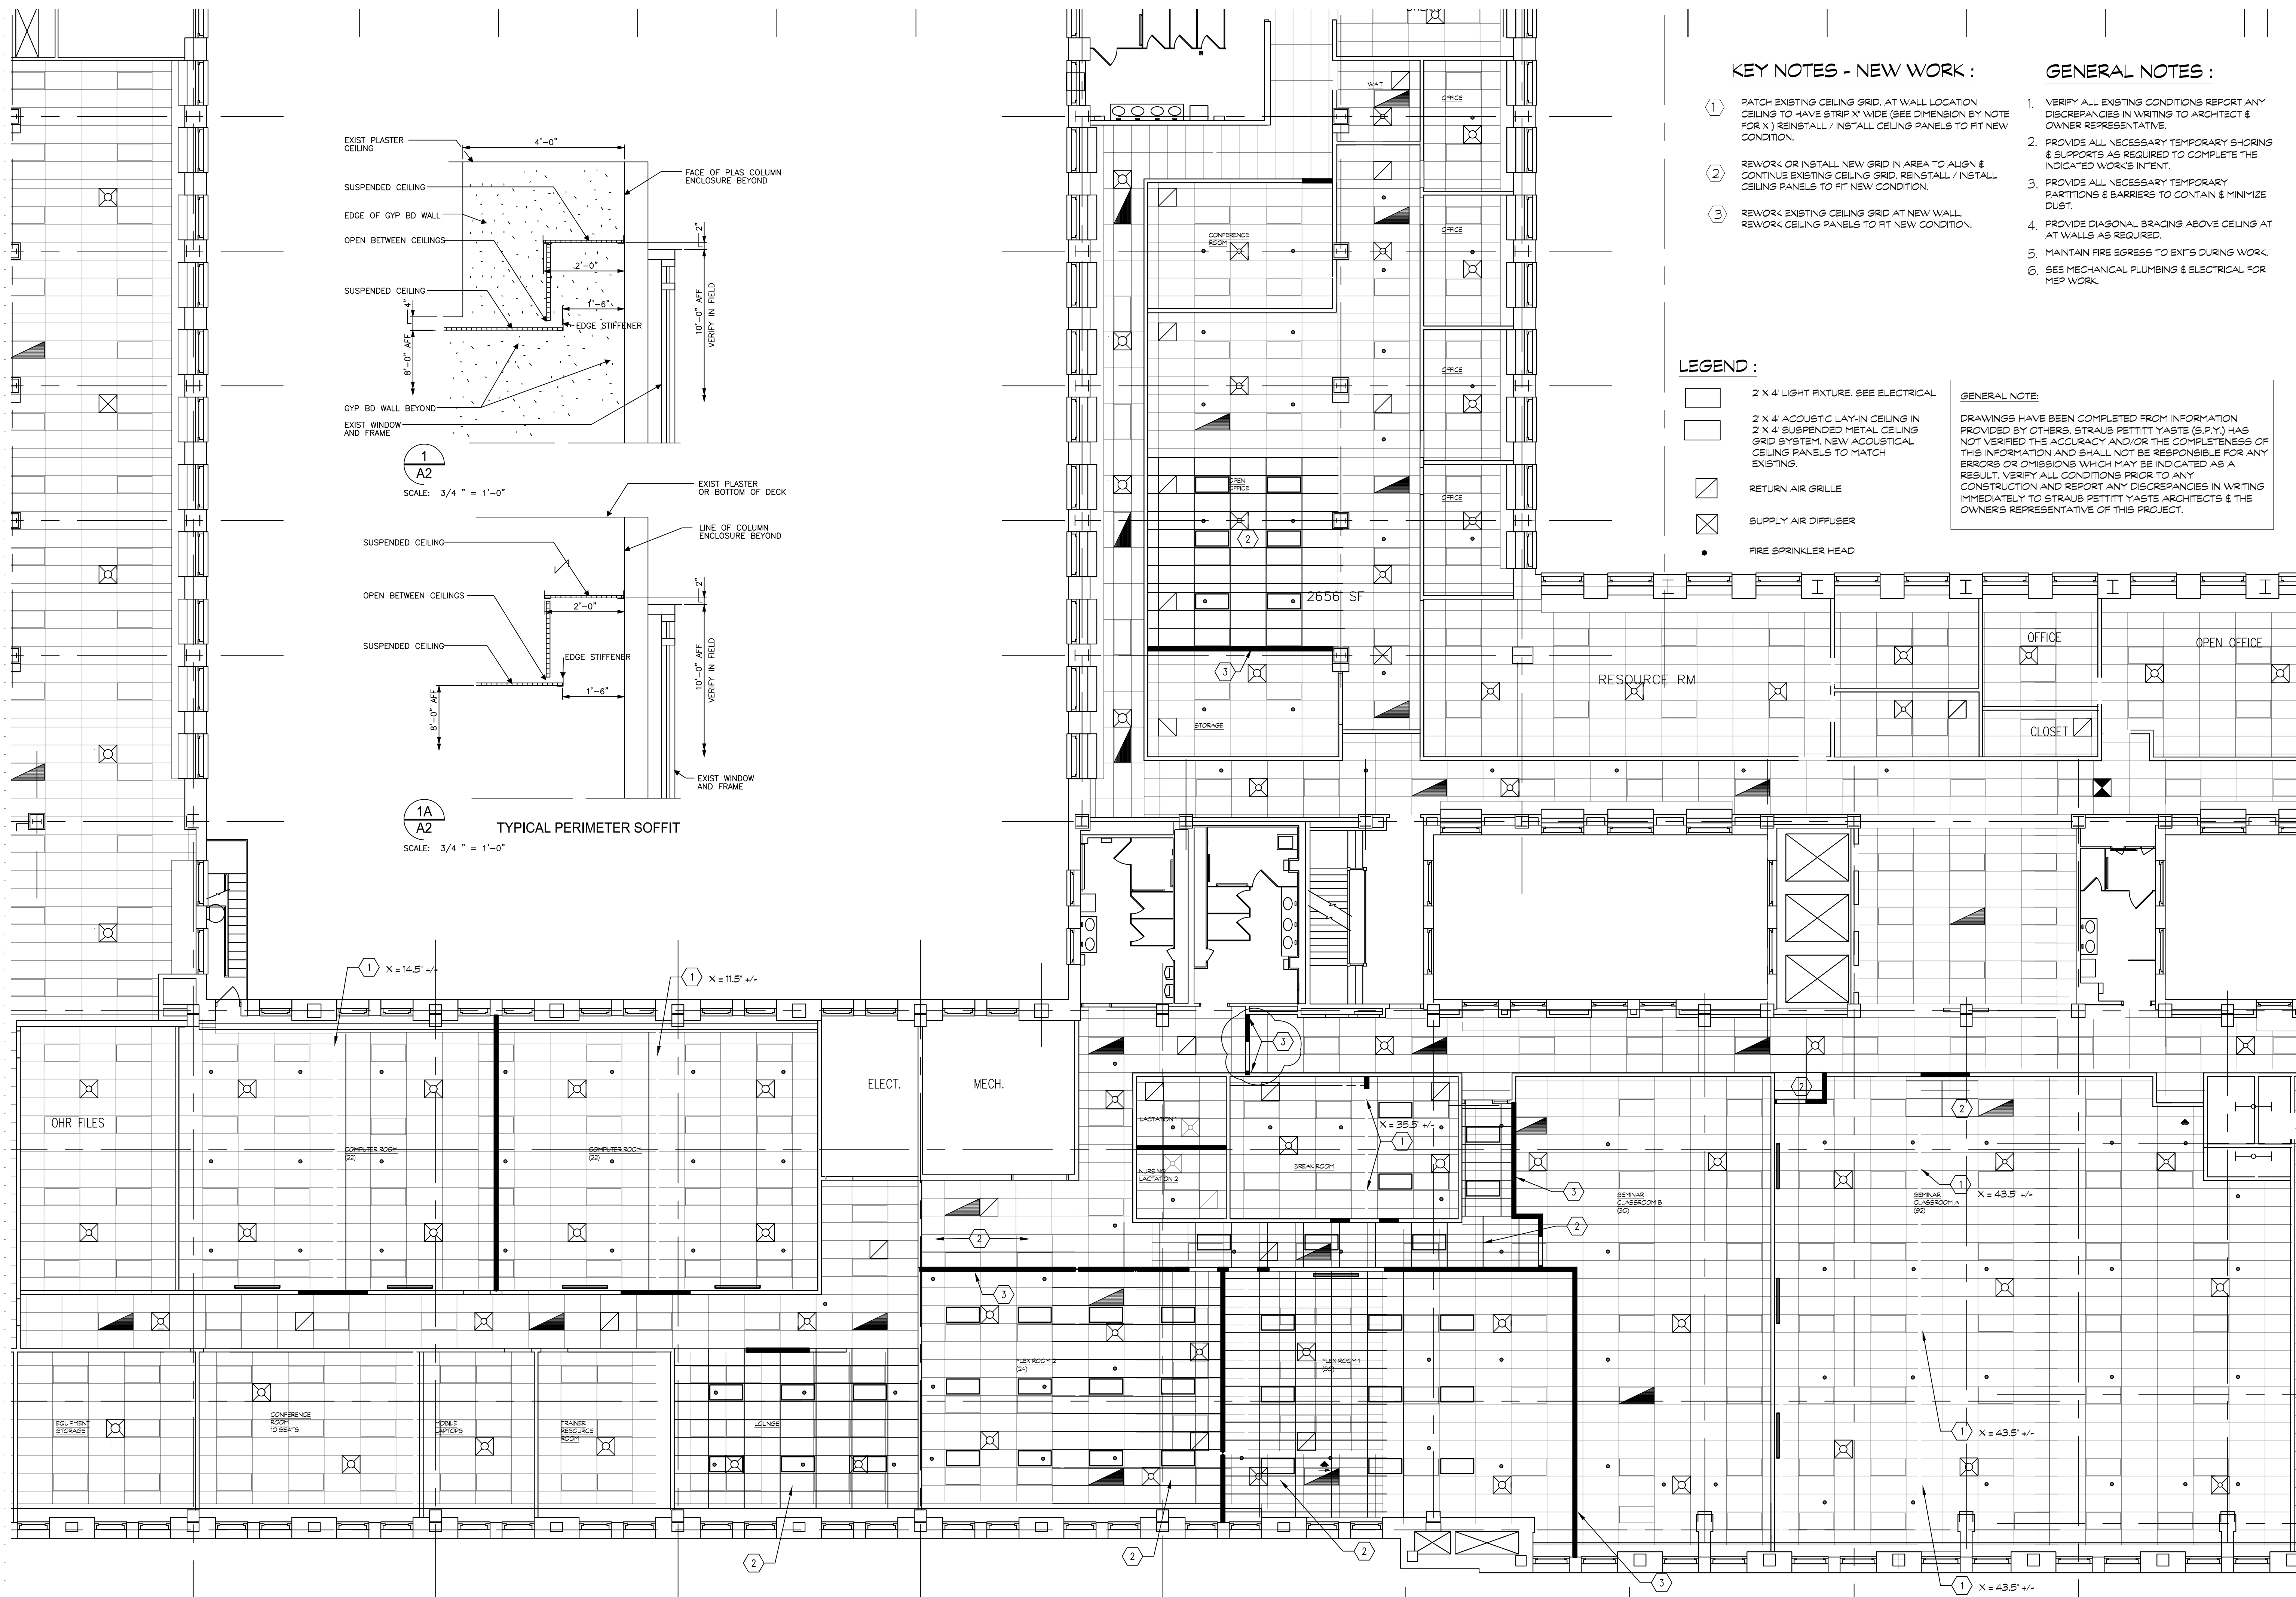

KEY NOTES - NEW WORK :

- 1 PATCH EXISTING CEILING GRID, AT WALL LOCATION CEILING TO HAVE STRIP X" WIDE (SEE DIMENSION BY NOTE FOR X) REINSTALL / INSTALL CEILING PANELS TO FIT NEW CONDITION.
- 2 REWORK OR INSTALL NEW GRID IN AREA TO ALIGN & CONTINUE EXISTING CEILING GRID, REINSTALL / INSTALL CEILING PANELS TO FIT NEW CONDITION.
- 3 REWORK EXISTING CEILING GRID AT NEW WALL, REWORK CEILING PANELS TO FIT NEW CONDITION.

GENERAL NOTES :

- 1. VERIFY ALL EXISTING CONDITIONS REPORT ANY DISCREPANCIES IN WRITING TO ARCHITECT & OWNER REPRESENTATIVE.
- 2. PROVIDE ALL NECESSARY TEMPORARY SHORING & SUPPORTS AS REQUIRED TO COMPLETE THE INDICATED WORKS INTENT.
- 3. PROVIDE ALL NECESSARY TEMPORARY PARTITIONS & BARRIERS TO CONTAIN & MINIMIZE DUST.
- 4. PROVIDE DIAGONAL BRACING ABOVE CEILING AT AT WALLS AS REQUIRED.
- 5. MAINTAIN FIRE EGRESS TO EXITS DURING WORK.
- 6. SEE MECHANICAL PLUMBING & ELECTRICAL FOR MEP WORK.

LEGEND :

- 2 X 4' LIGHT FIXTURE, SEE ELECTRICAL
- 2 X 4' ACOUSTIC LAY-IN CEILING IN 2 X 4' SUSPENDED METAL CEILING GRID SYSTEM, NEW ACOUSTICAL CEILING PANELS TO MATCH EXISTING.
- RETURN AIR GRILLE
- SUPPLY AIR DIFFUSER
- FIRE SPRINKLER HEAD

GENERAL NOTE:
DRAWINGS HAVE BEEN COMPLETED FROM INFORMATION PROVIDED BY OTHERS. STRAUB PETTITT YASTE (S.P.Y.) HAS NOT VERIFIED THE ACCURACY AND/OR THE COMPLETENESS OF THIS INFORMATION AND SHALL NOT BE RESPONSIBLE FOR ANY ERRORS OR OMISSIONS WHICH MAY BE INDICATED AS A RESULT. VERIFY ALL CONDITIONS PRIOR TO ANY CONSTRUCTION AND REPORT ANY DISCREPANCIES IN WRITING IMMEDIATELY TO STRAUB PETTITT YASTE ARCHITECTS & THE OWNERS REPRESENTATIVE OF THIS PROJECT.

ADDENDUM NO 1 05-15-2025
ISSUED FOR BIDS 04-29-2025
50% PHASE 500 02-12-2025


DEPT. OF HEALTH & HUMAN SERVICES
CADILLAC PLACE 4TH FLOOR
ANNEX TRAINING SUITE
BUILD-OUT

FILE NO: 491_24304_MNB

CADILLAC PLACE
3044 W. GRAND BLVD
DETROIT, MICHIGAN 48202

2434

STATE OF MICHIGAN
DEPARTMENT OF TECHNOLOGY, MANAGEMENT AND BUDGET
STATE FACILITIES ADMINISTRATION
DESIGN AND CONSTRUCTION DIVISION
ADAM P. LACH, RA, DIRECTOR

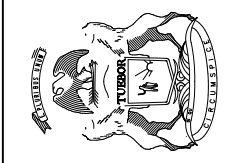

Straub Pettitt Yaste
850 NORTH CROOKS ROAD
SUITE 200
CLARKSVILLE, MICHIGAN 48017-1311
248-655-7777 PHONE
248-648-7761 FAX

REFLECTED CEILING PLAN, DETAILS

L	6	I	7	E	8	A
J				F		C
K	5	H	3	D	1	B
ANNEX						

A2