


INDEX


- 00.0 EXISTING GRADE ELEVATIONS.
 00.0 NEW FINISH GRADE ELEVATIONS.
 C.B. CATCH BASIN
 T.H. TEST HOLE LOCATIONS - CONSULT ARCHITECT FOR TEST HOLE INFORMATION IF REQUIRED
 — PROPERTY LINE
 PH PHYSICALLY HANDICAPPED PARKING SPACE INDICATION.
 X EXTERIOR LIGHTPOLE & FIXTURE - SEE ELECTRICAL DRAWINGS.

SITE NOTES:

1. BENCH MARK, PROPERTY DIMENSIONS, SITE UTILITY LOCATIONS, CURB LOCATIONS, EXISTING GRADE ELEVATIONS, ETC. IS INFORMATION TRANSFERRED FROM SURVEY FURNISHED BY DEPARTMENT OF MANAGEMENT AND BUDGET - BUREAU OF FACILITIES - STATE OF MICHIGAN - DATED OCTOBER 1979 - STATE ACCOUNT - 110-07-2750-800
2. BENCH MARK: ARROW ON NORTH RIM OF ELECTRIC MANHOLE ELEVATION - 591.33
3. EXISTING AND NEW FINISH GRADE ELEVATIONS ARE PRECEDED BY 500.0
4. SEE LANDSCAPE PLAN - SHEET #L1 FOR PLANTING AND DETAILS.
5. SEE IRRIGATION PLAN - SHEET #L2 FOR SLEEVE LOCATIONS - SLEEVES SHALL BE FURNISHED AND INSTALLED BY THE GENERAL CONTRACTOR.

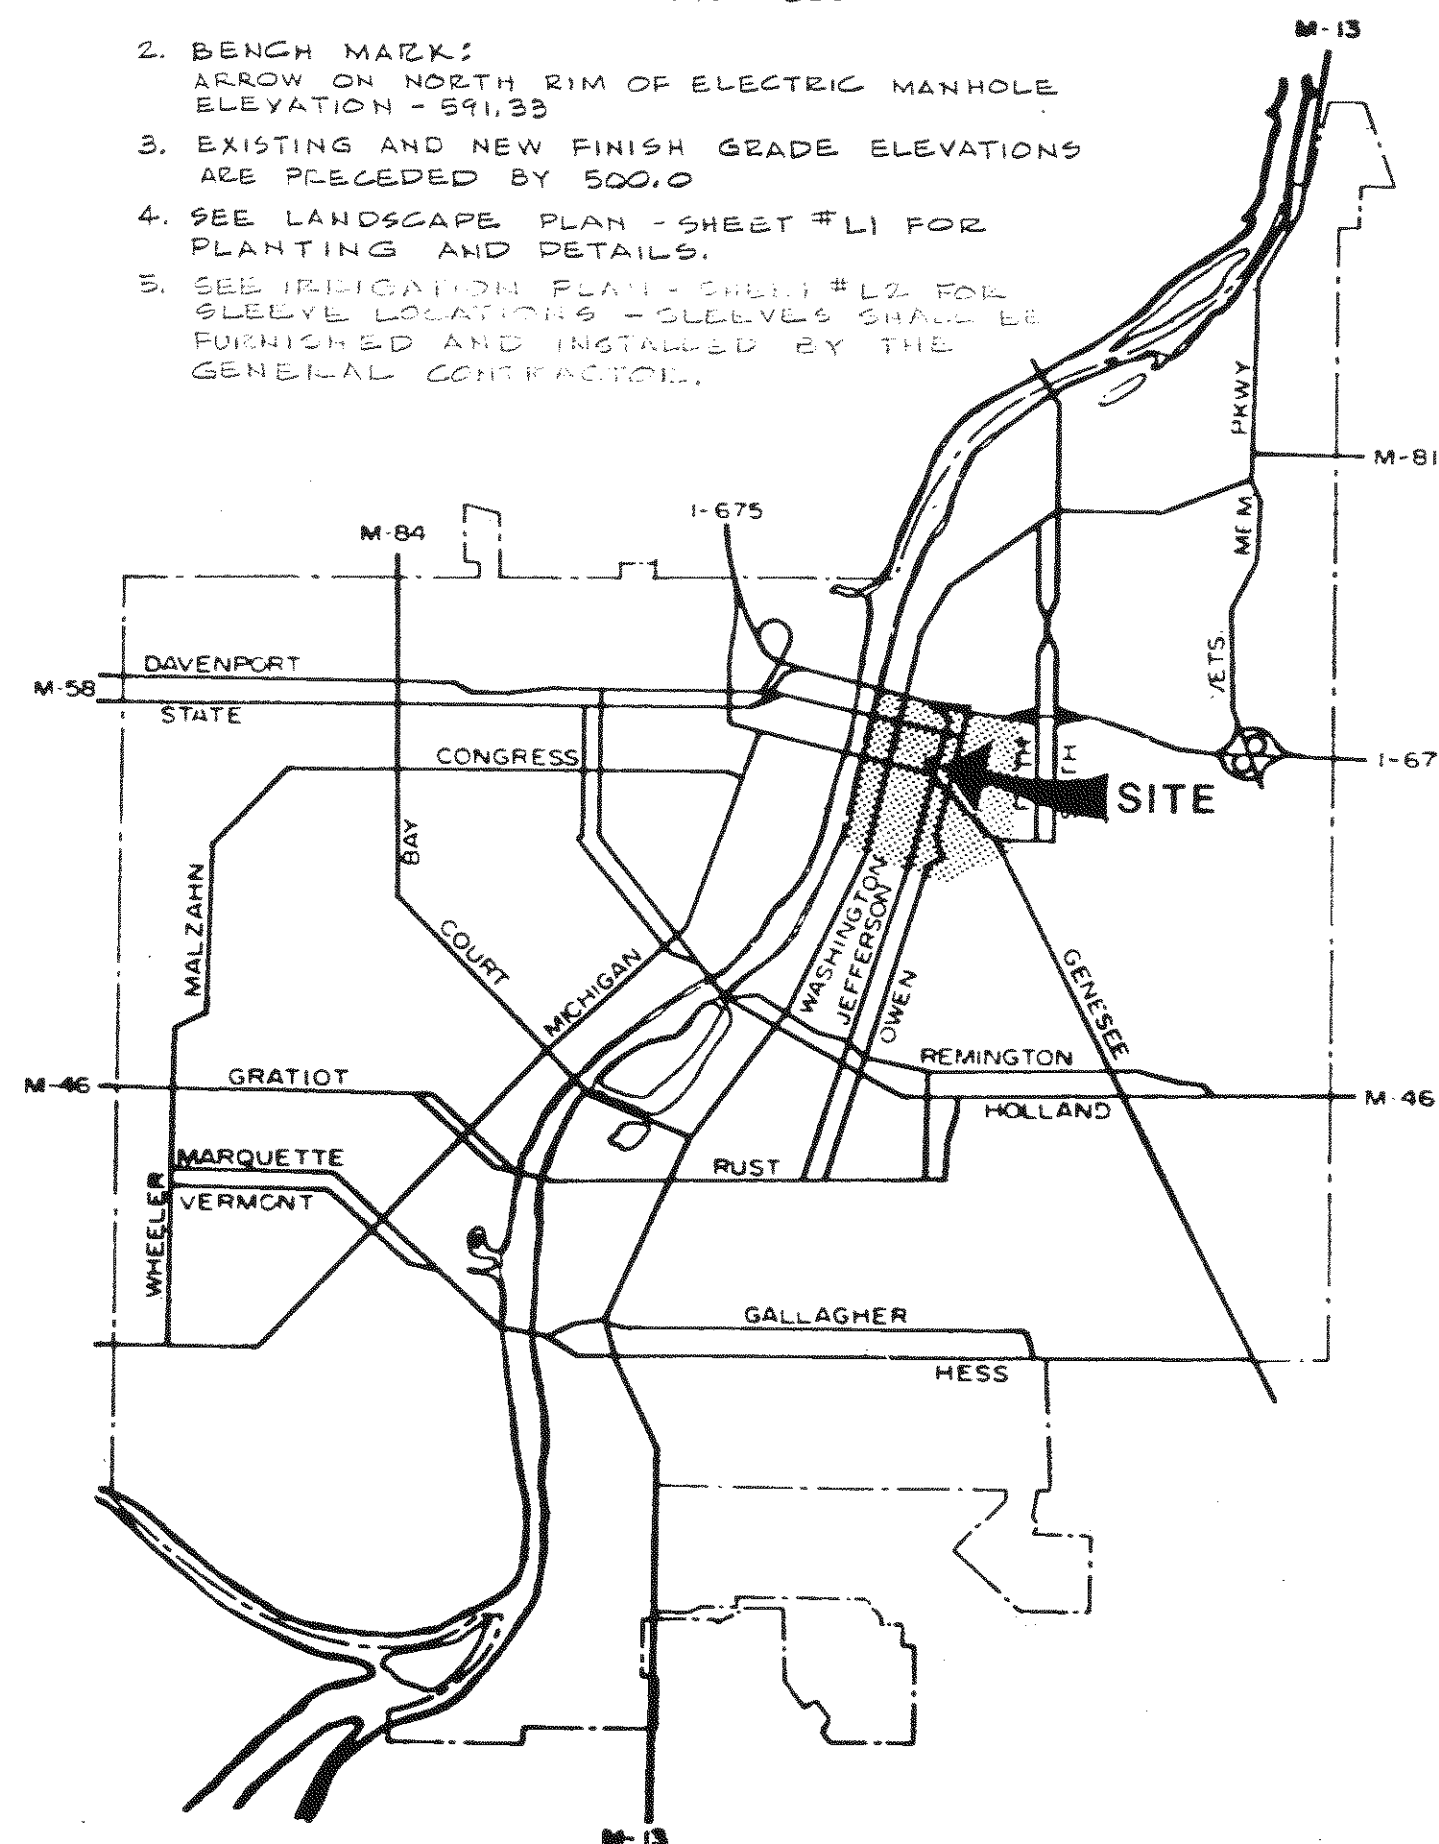


LOCATION MAP

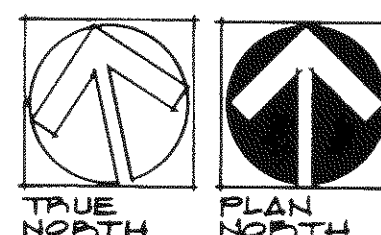


SITE PLAN


SCALE: 1" = 20'-0"

NOTE:
 SEE SITE SURVEY AND DEMOLITION PLAN - SHEET #D1 FOR WATER MAIN, STORM AND SANITARY LINES, ELECTRICAL POWER, TELEPHONE DATA, ETC.

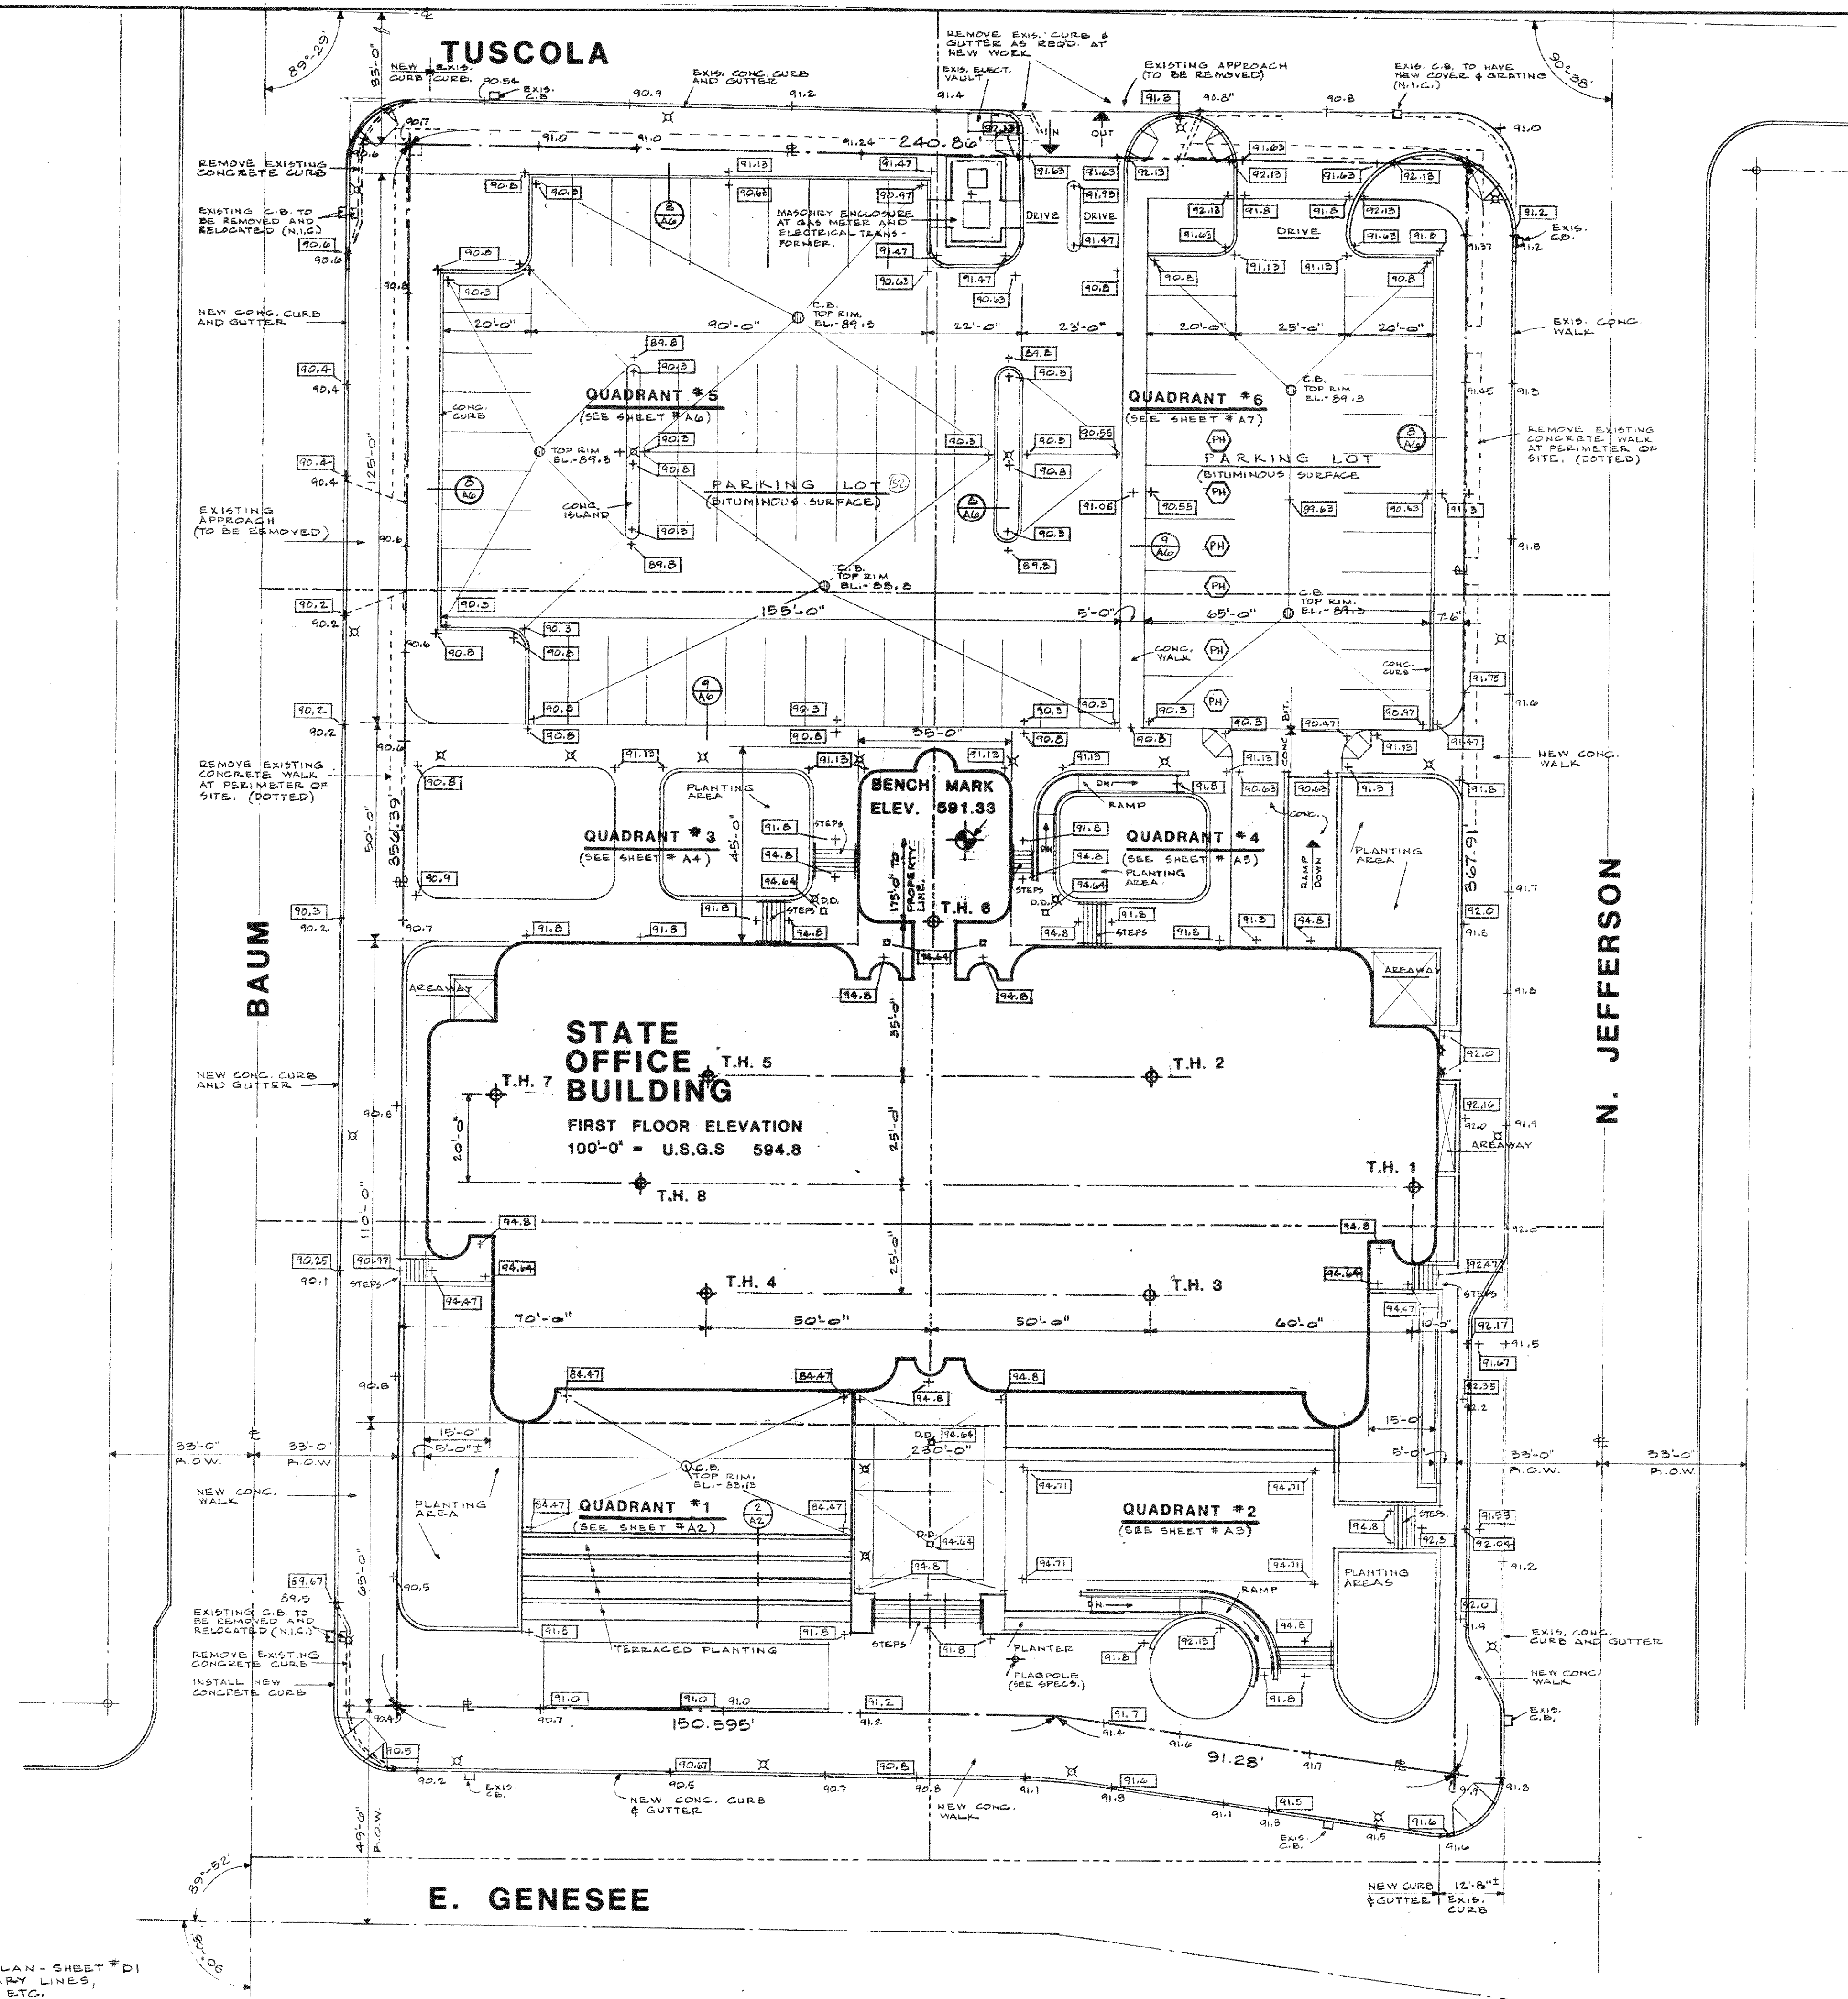

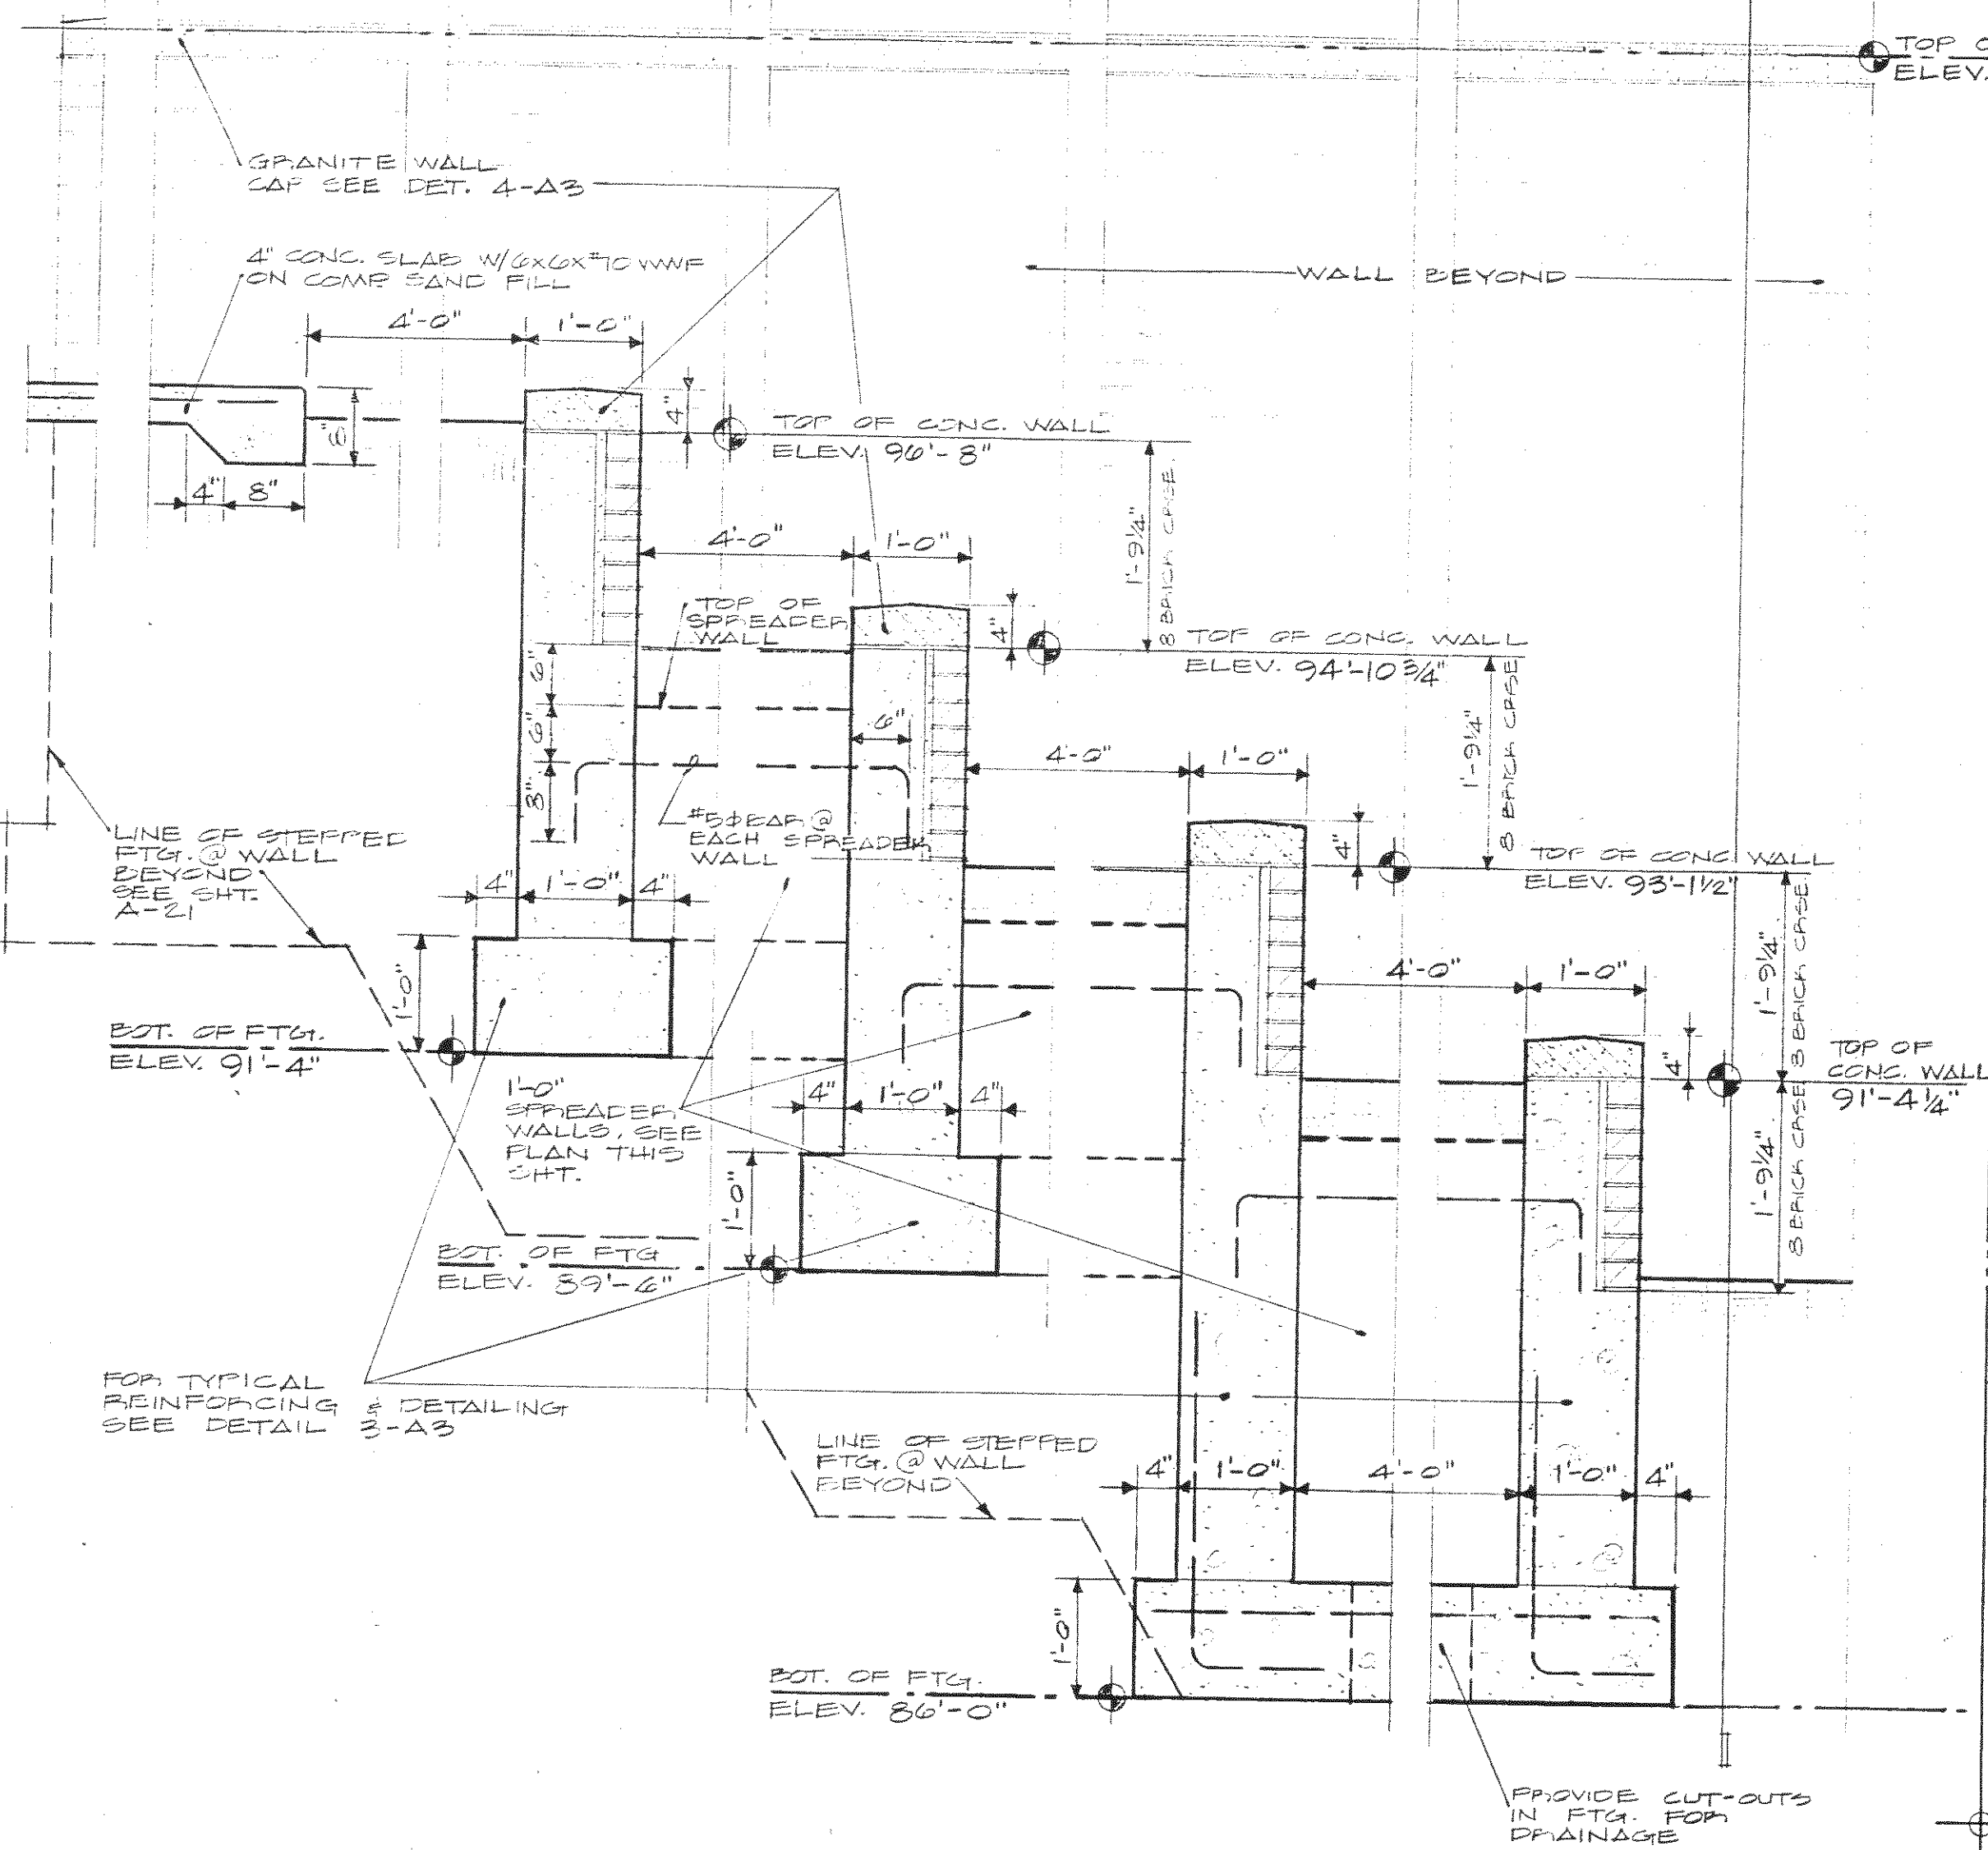


ELEVATION





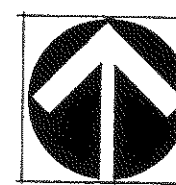


QUADRANT #1 SITE PLAN

NOTES


- 1) SEE SHEET A-1 FOR PROP. DIMENSIONS
- 2) EXIST'G./FINISH GRADES ALSO QUADRIANT LAYOUT.
PAVING LAYOUT IS BASED ON A 5'-0" X 5'-0" GRID
OR MULTIPLES THEREOF.
- 3) B.O.F. = BOTTOM OF FOOTING ELEV.
- 4) 5'-0" - 0'-0" = STEP UP FOOTING PER-SPECIFIED DIMENSION

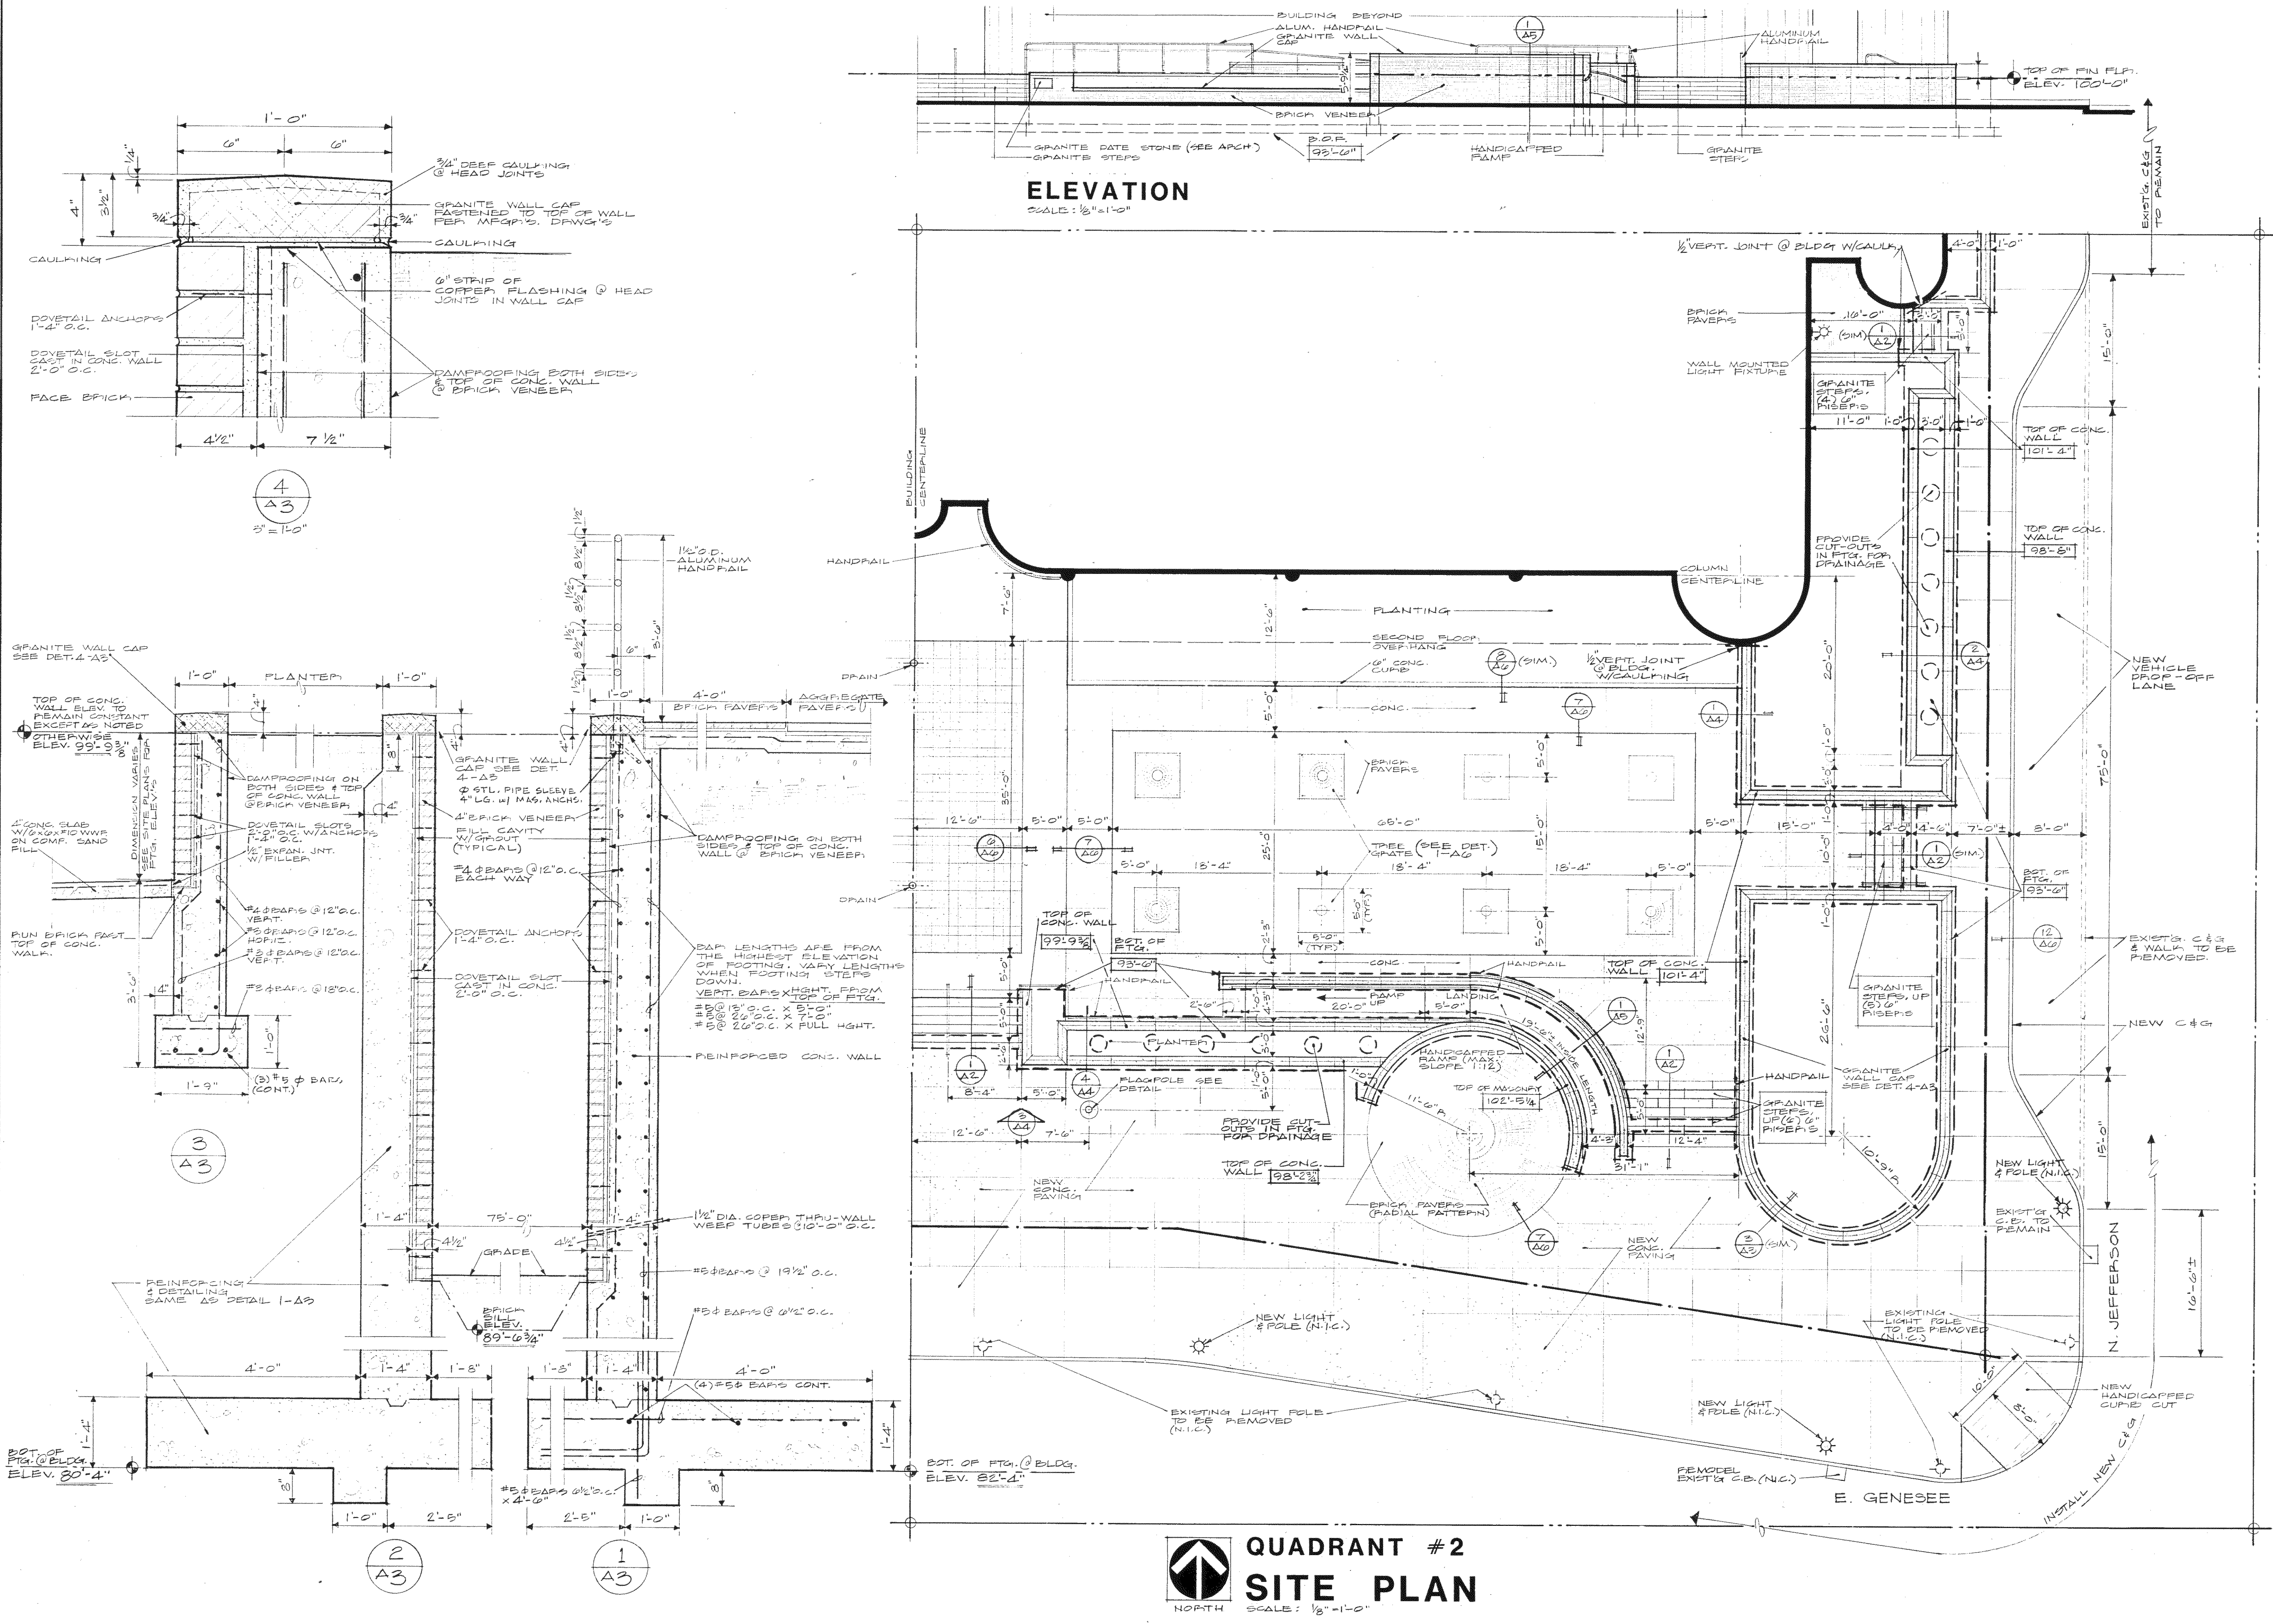

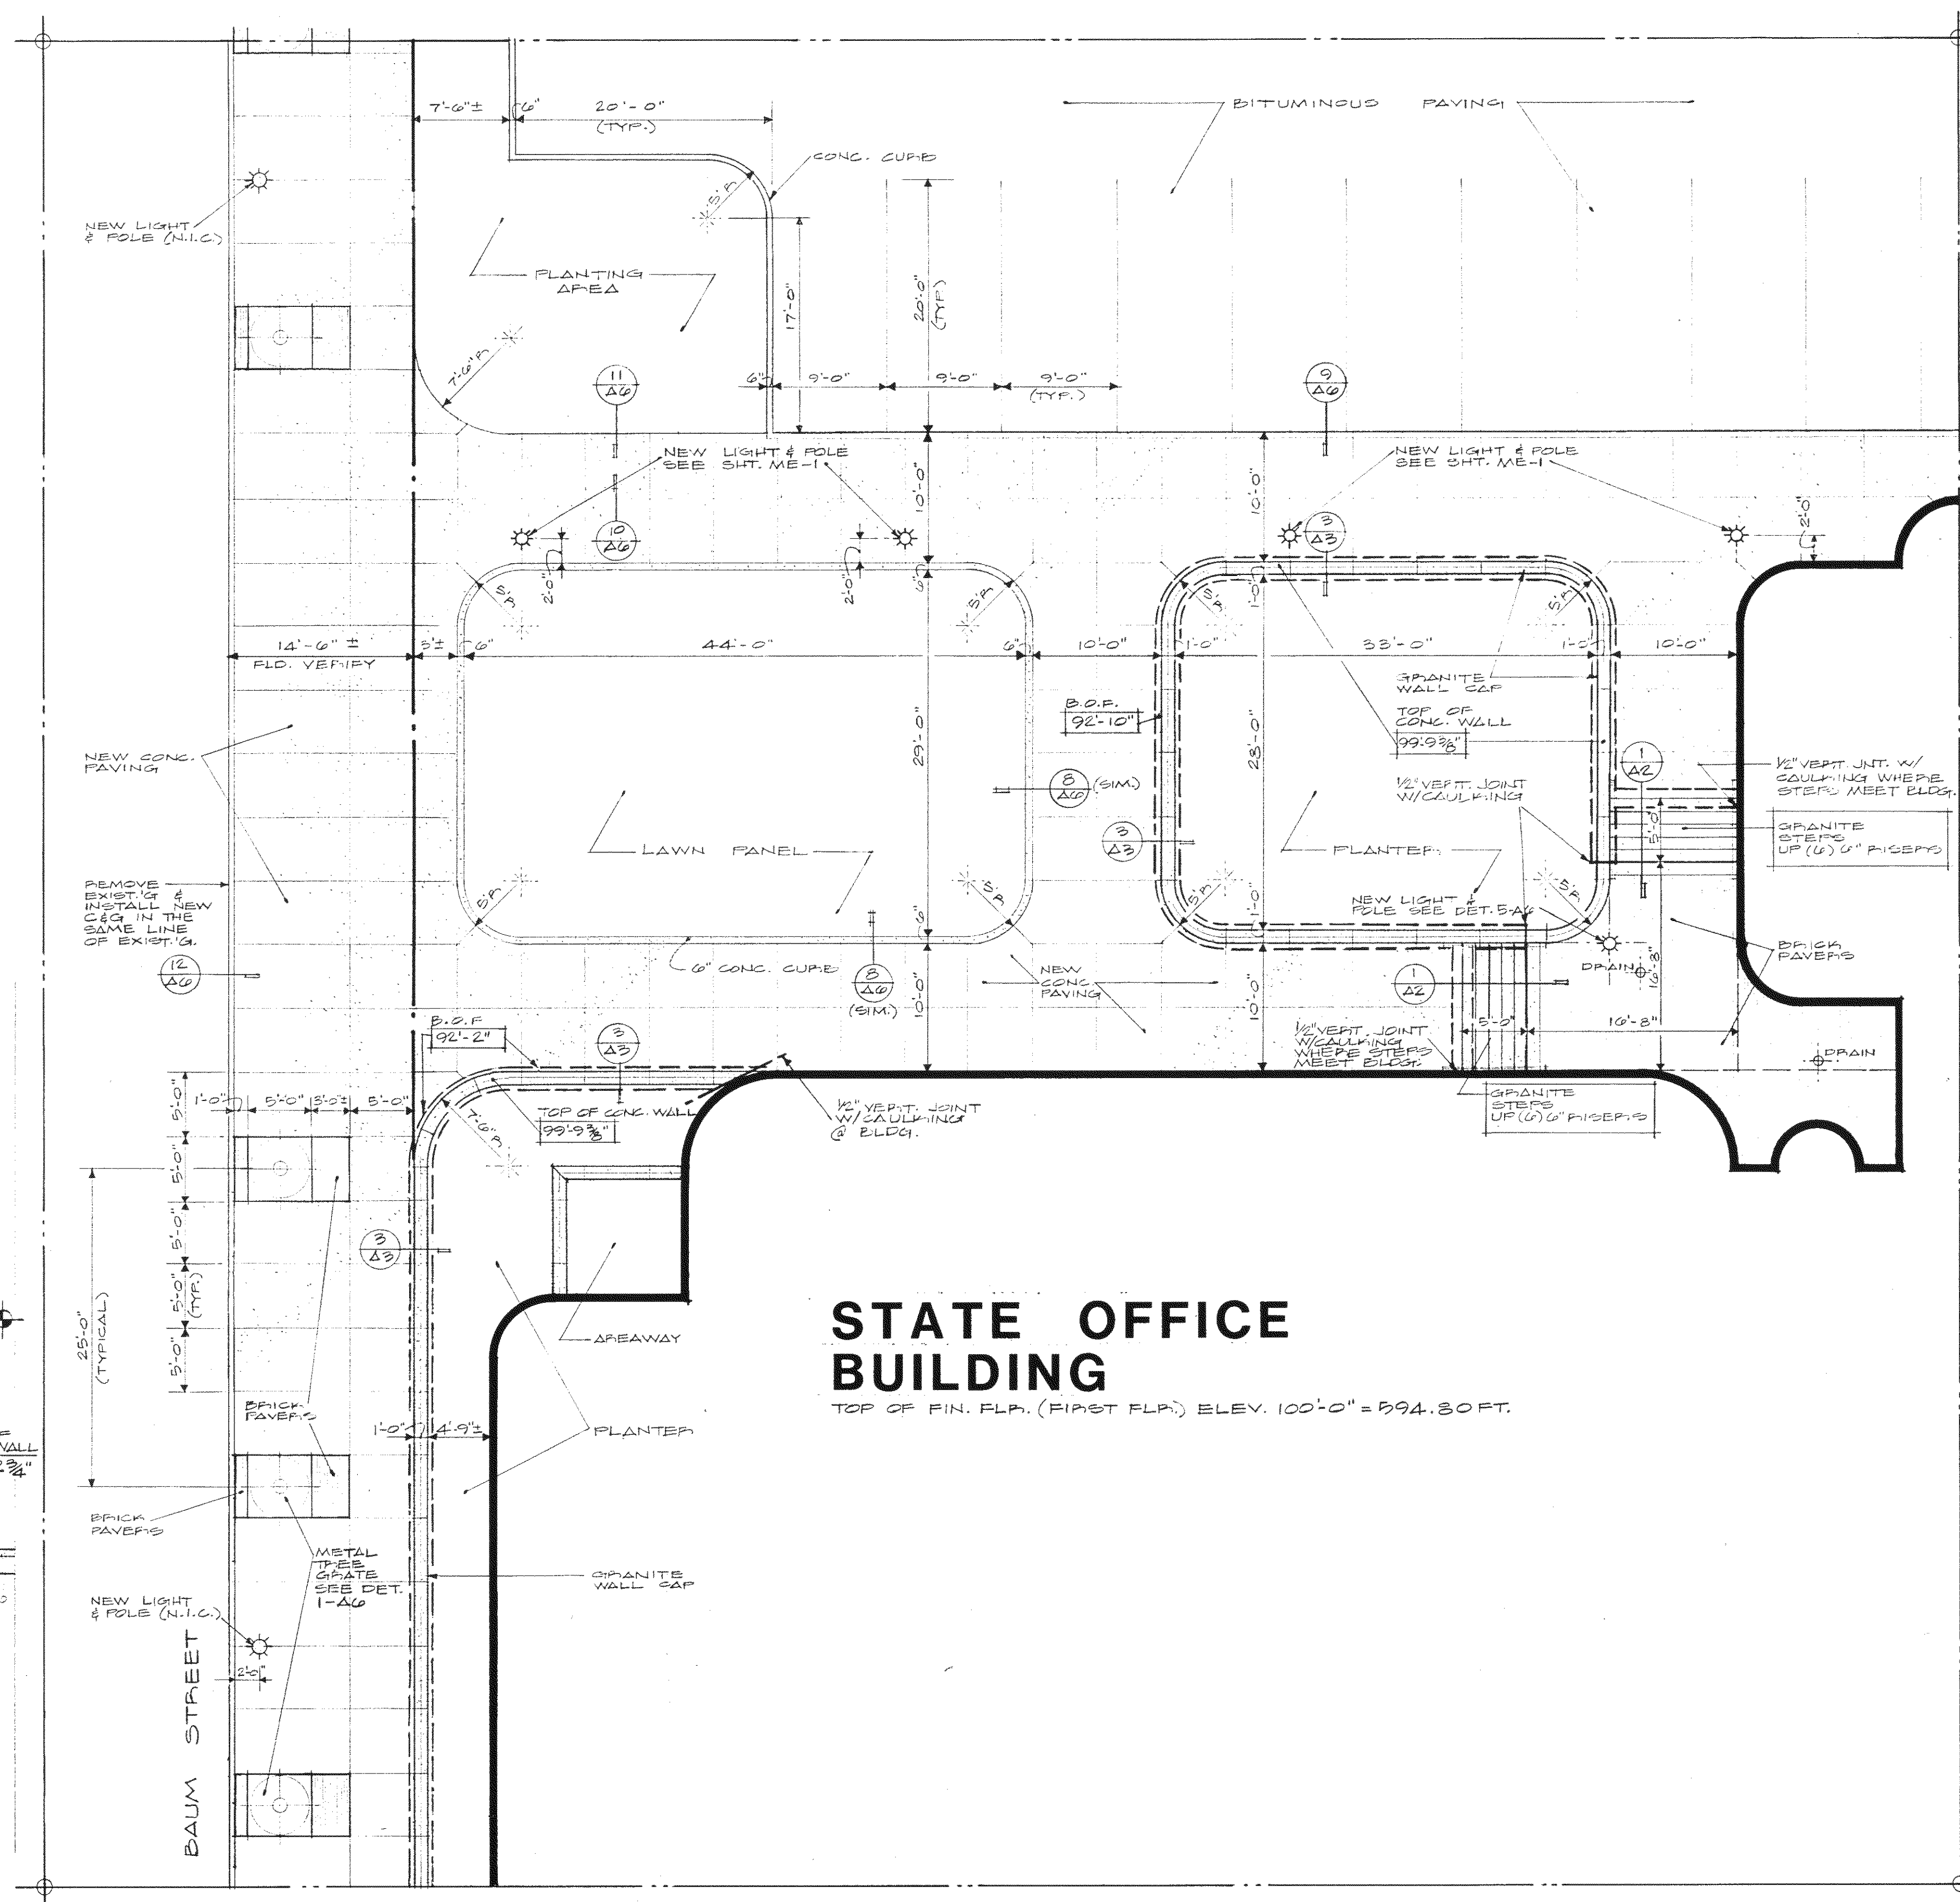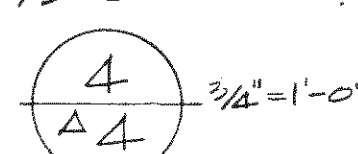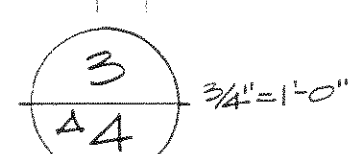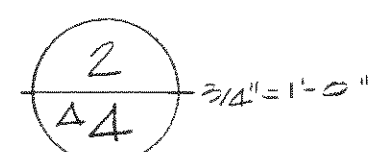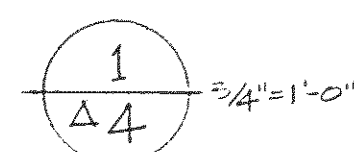

**STATE OFFICE
BUILDING**


TOP OF FIN. FLR. (FIRST FLR.) ELEV. 100'-0" = 594.80 FT.

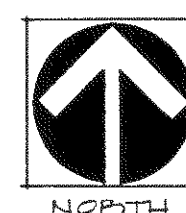


QUADRANT #3 SITE PLAN

SCALE: 1/8" = 1'-0"


NOTES:
1) SEE SHT. A-1 FOR PROP. DIMENSIONS
2) EXIST'G / FINISH GRADES, ALSO QUADRANT
LAYOUT
3) PAVING LAYOUT IS BASED ON A 5'-0" X 5'-0" GRID.

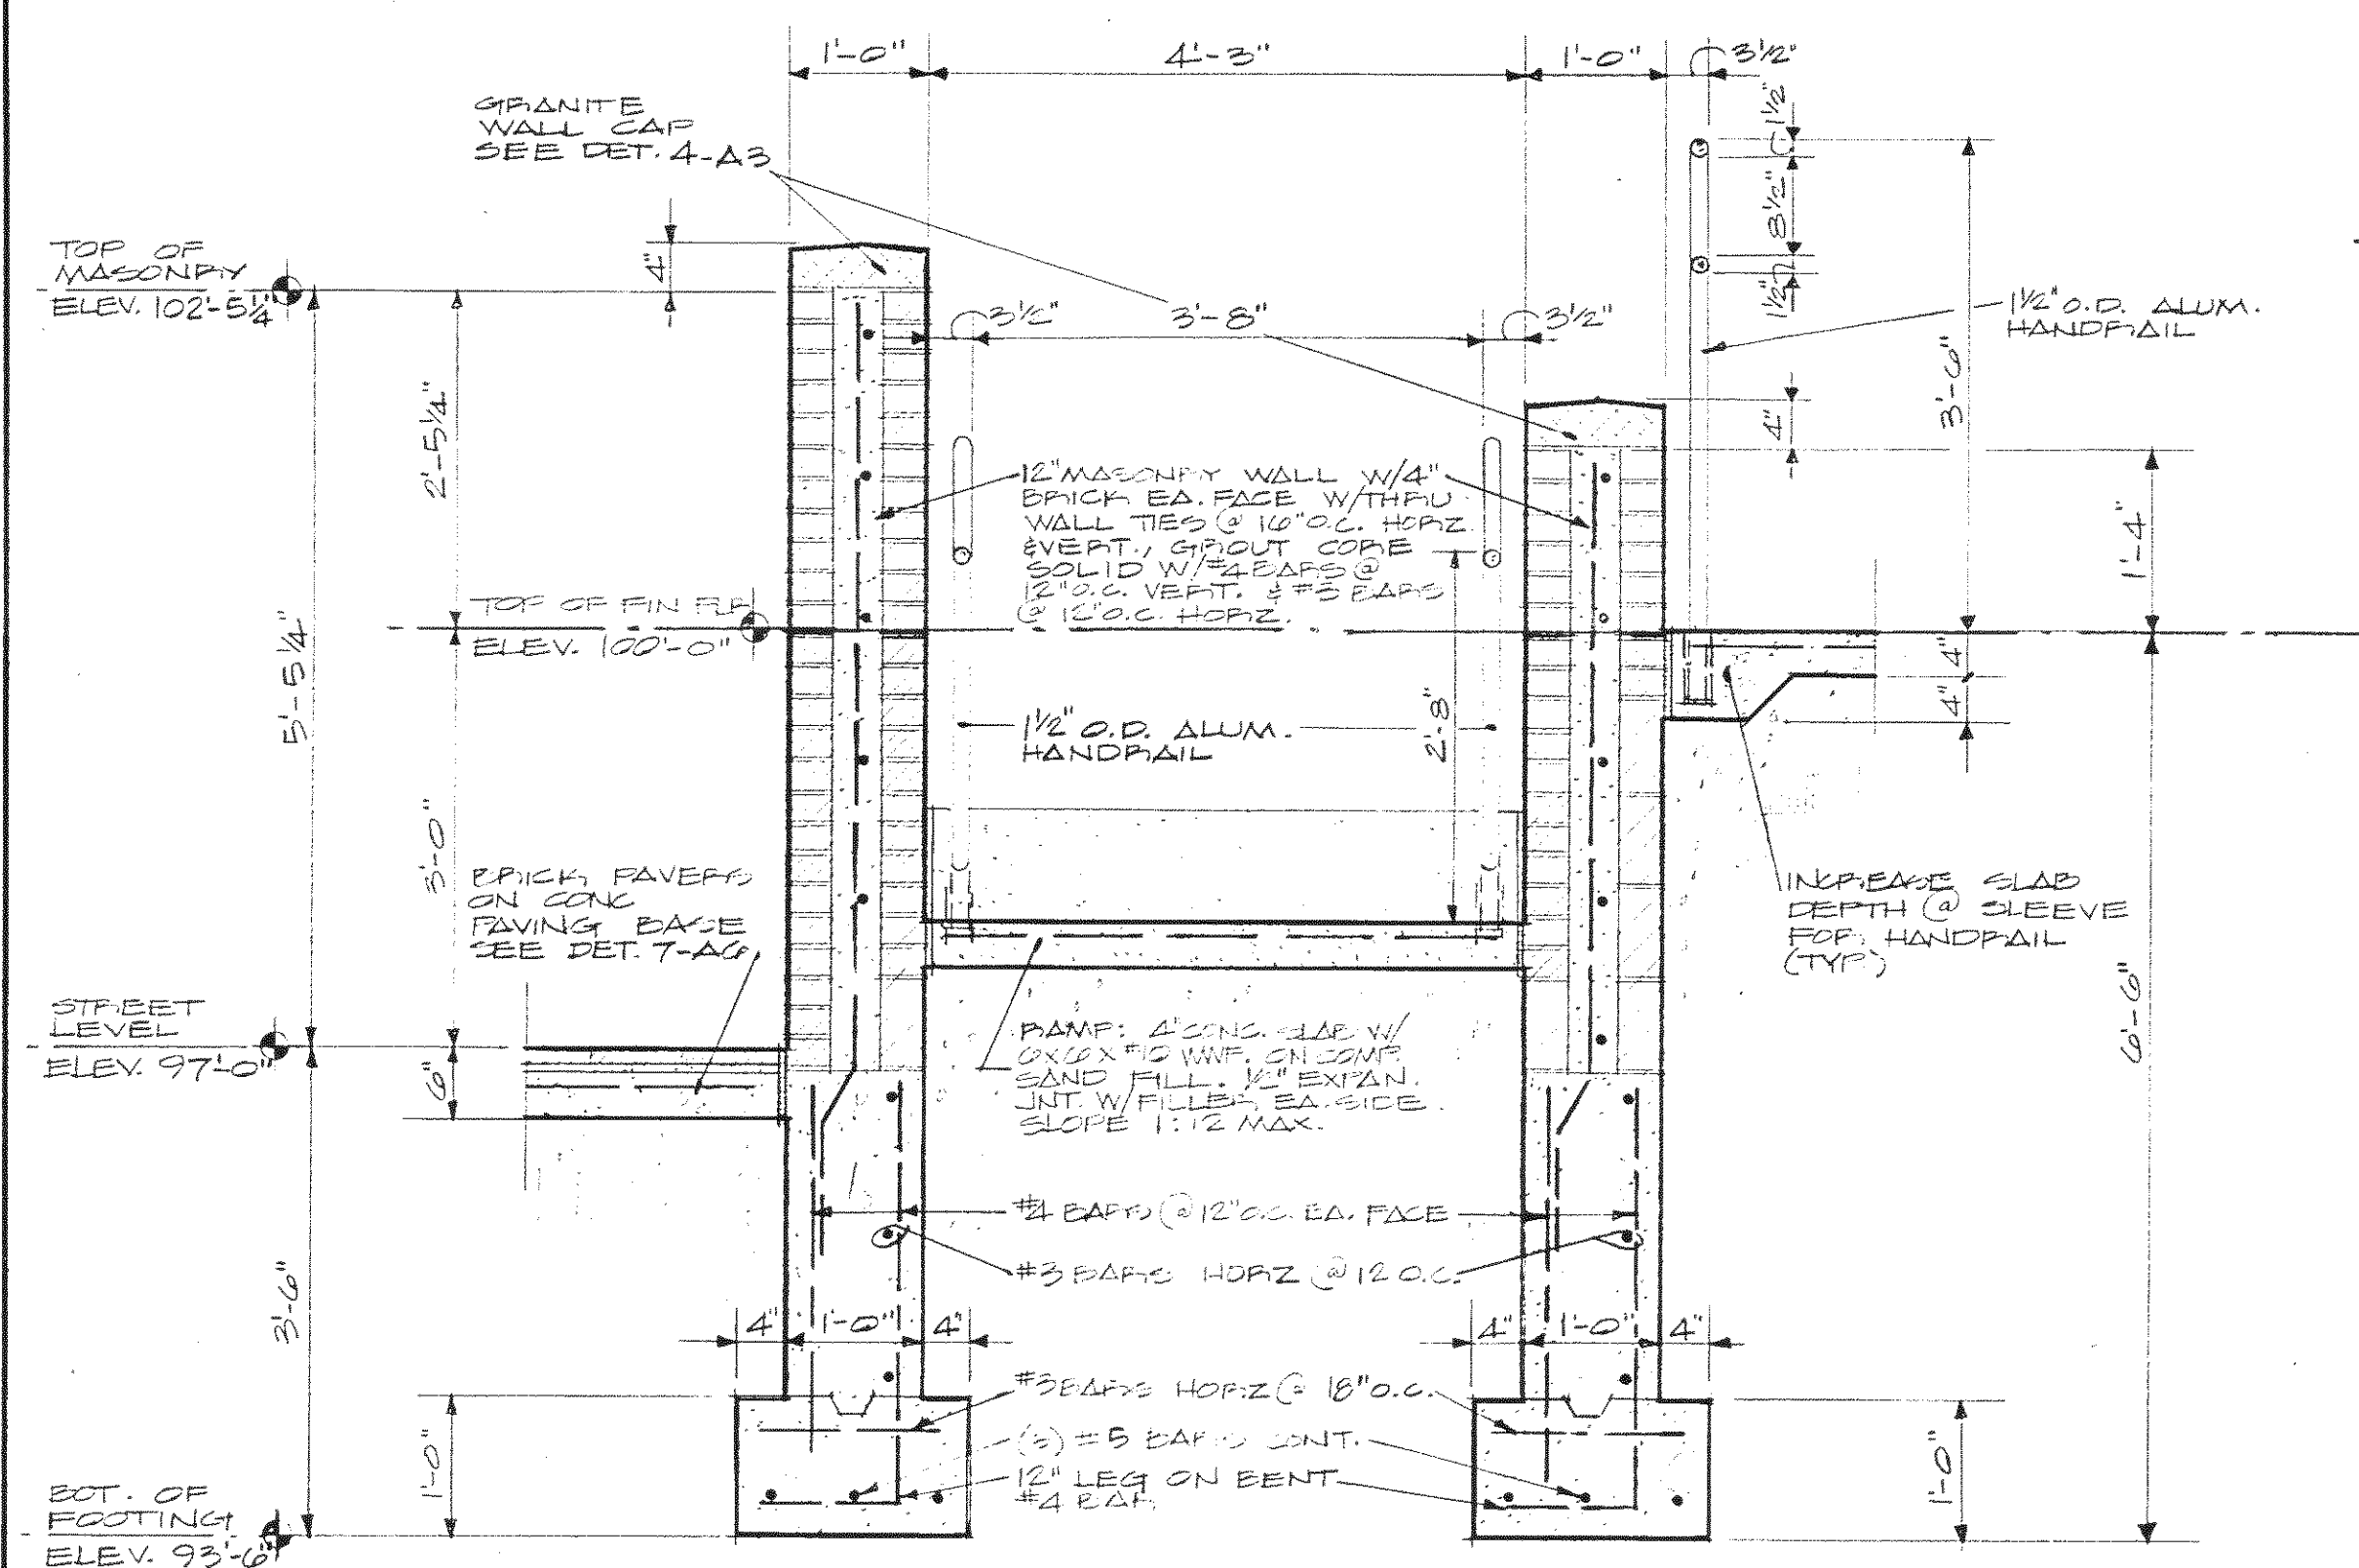

1 HANDICAPPED RAMP
Δ5 3/4" = 1'-0"

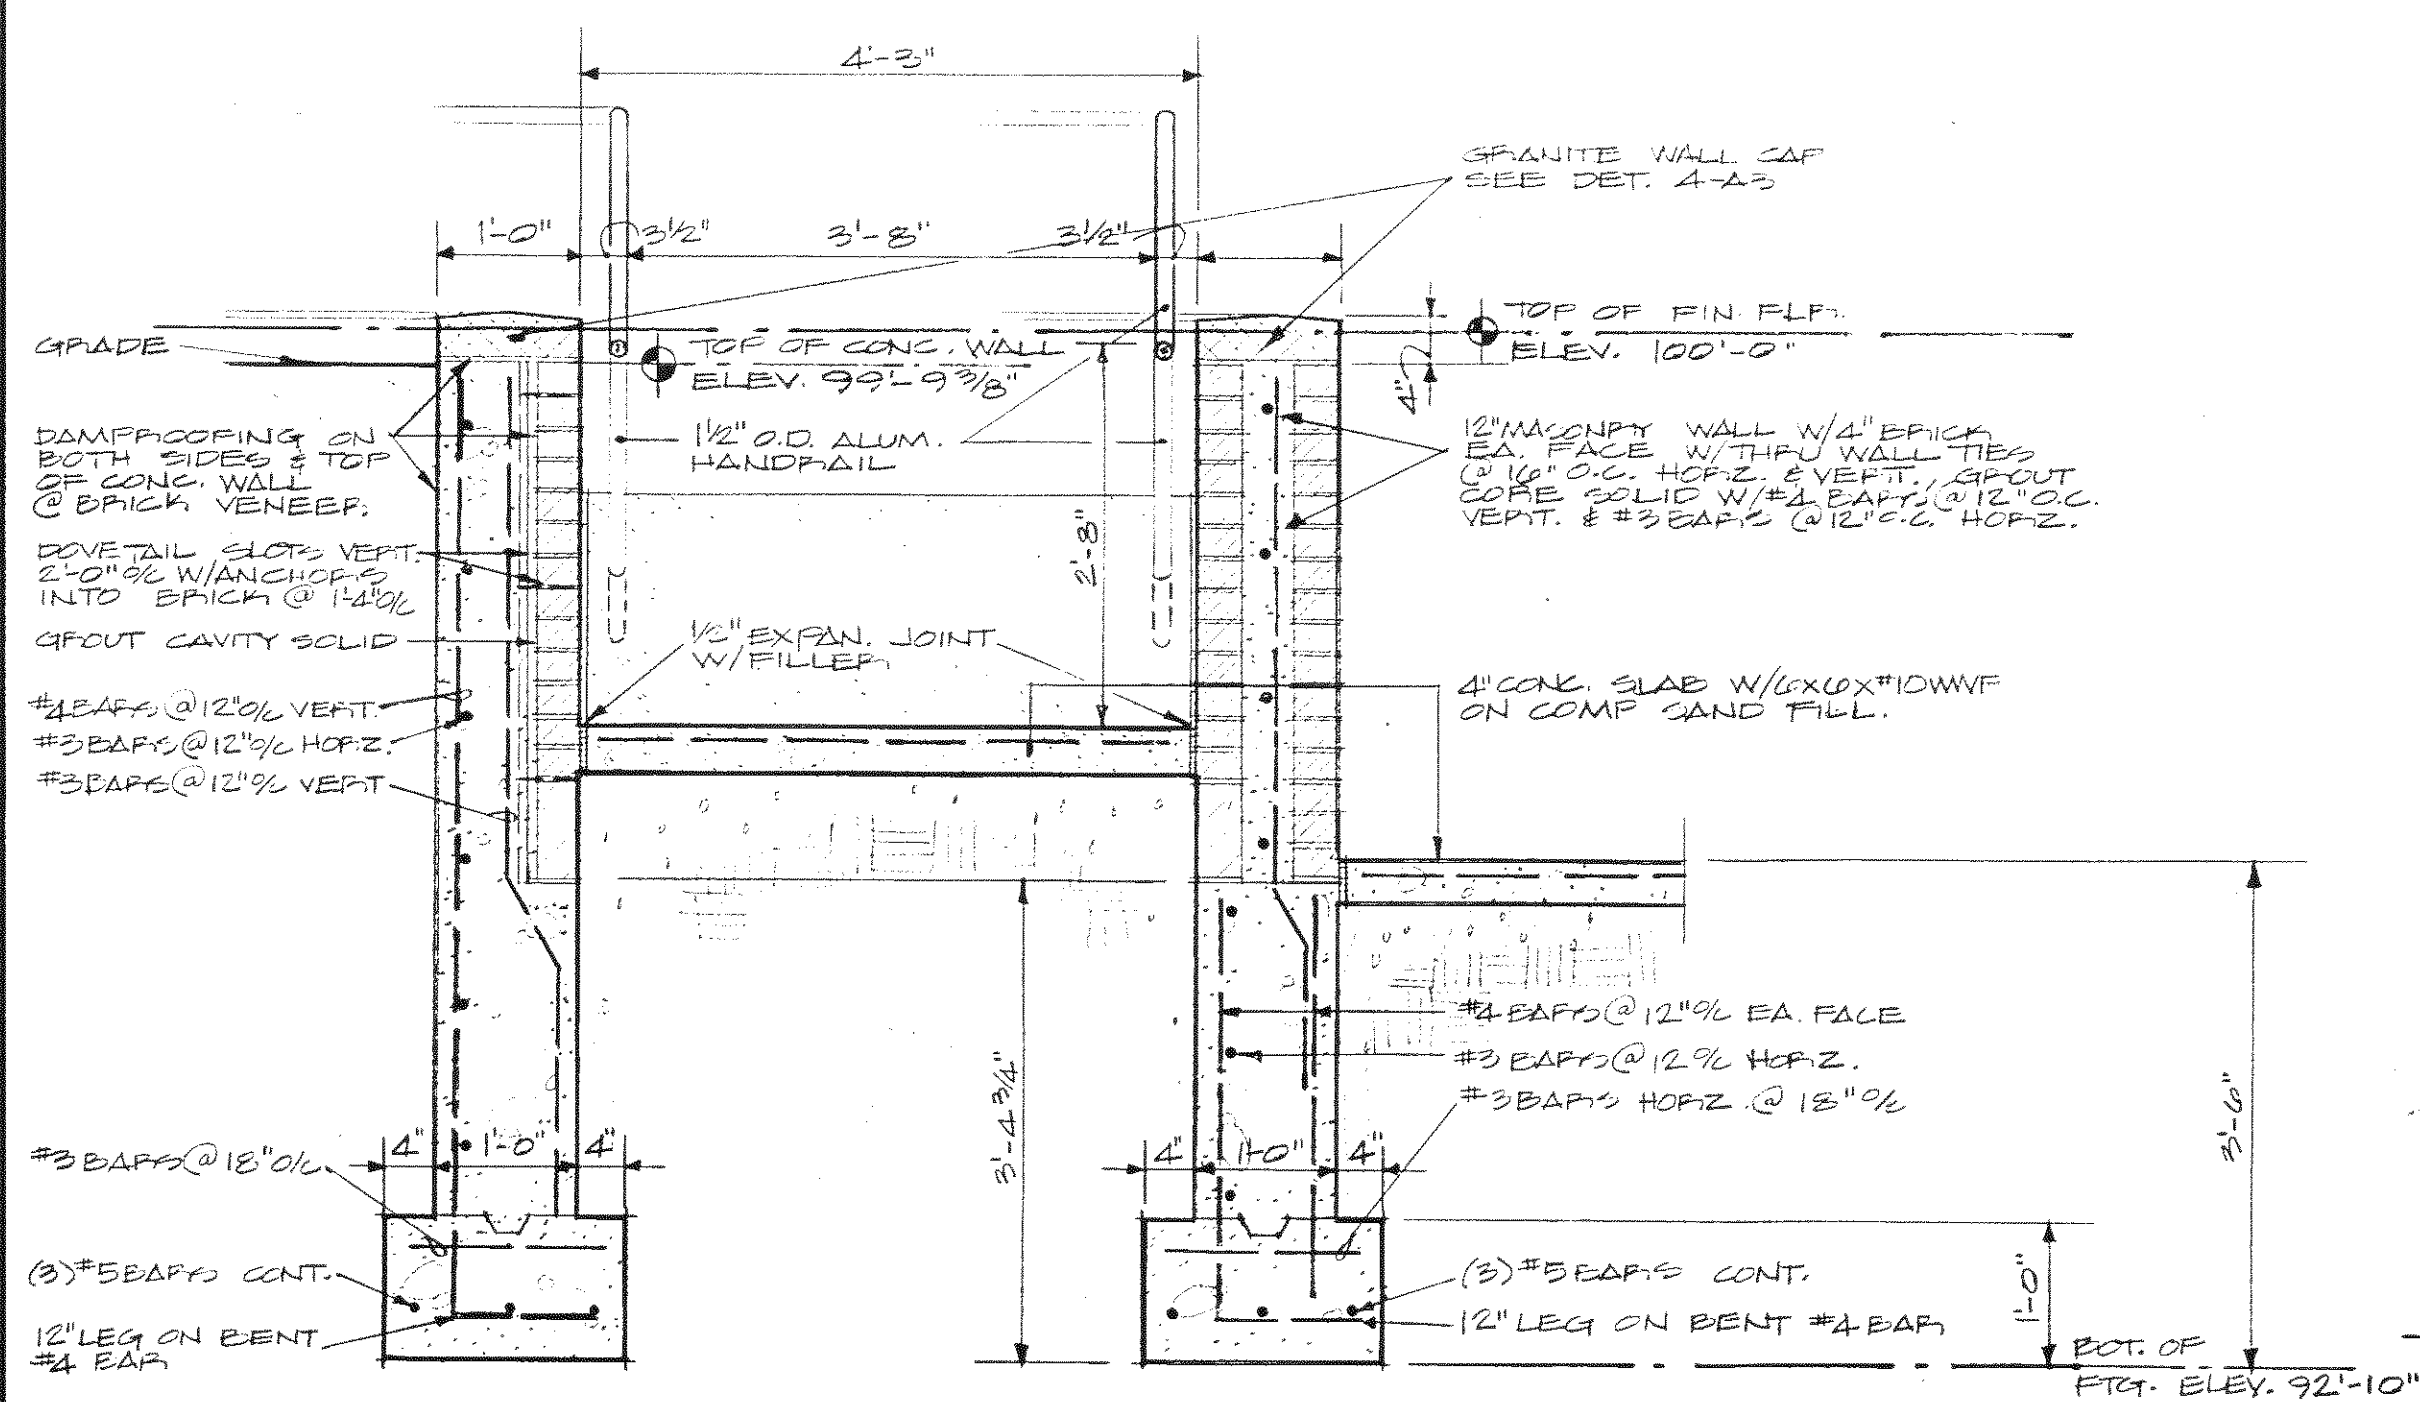

2 HANDICAPPED RAMP
A5 3/4" = 1'-0"

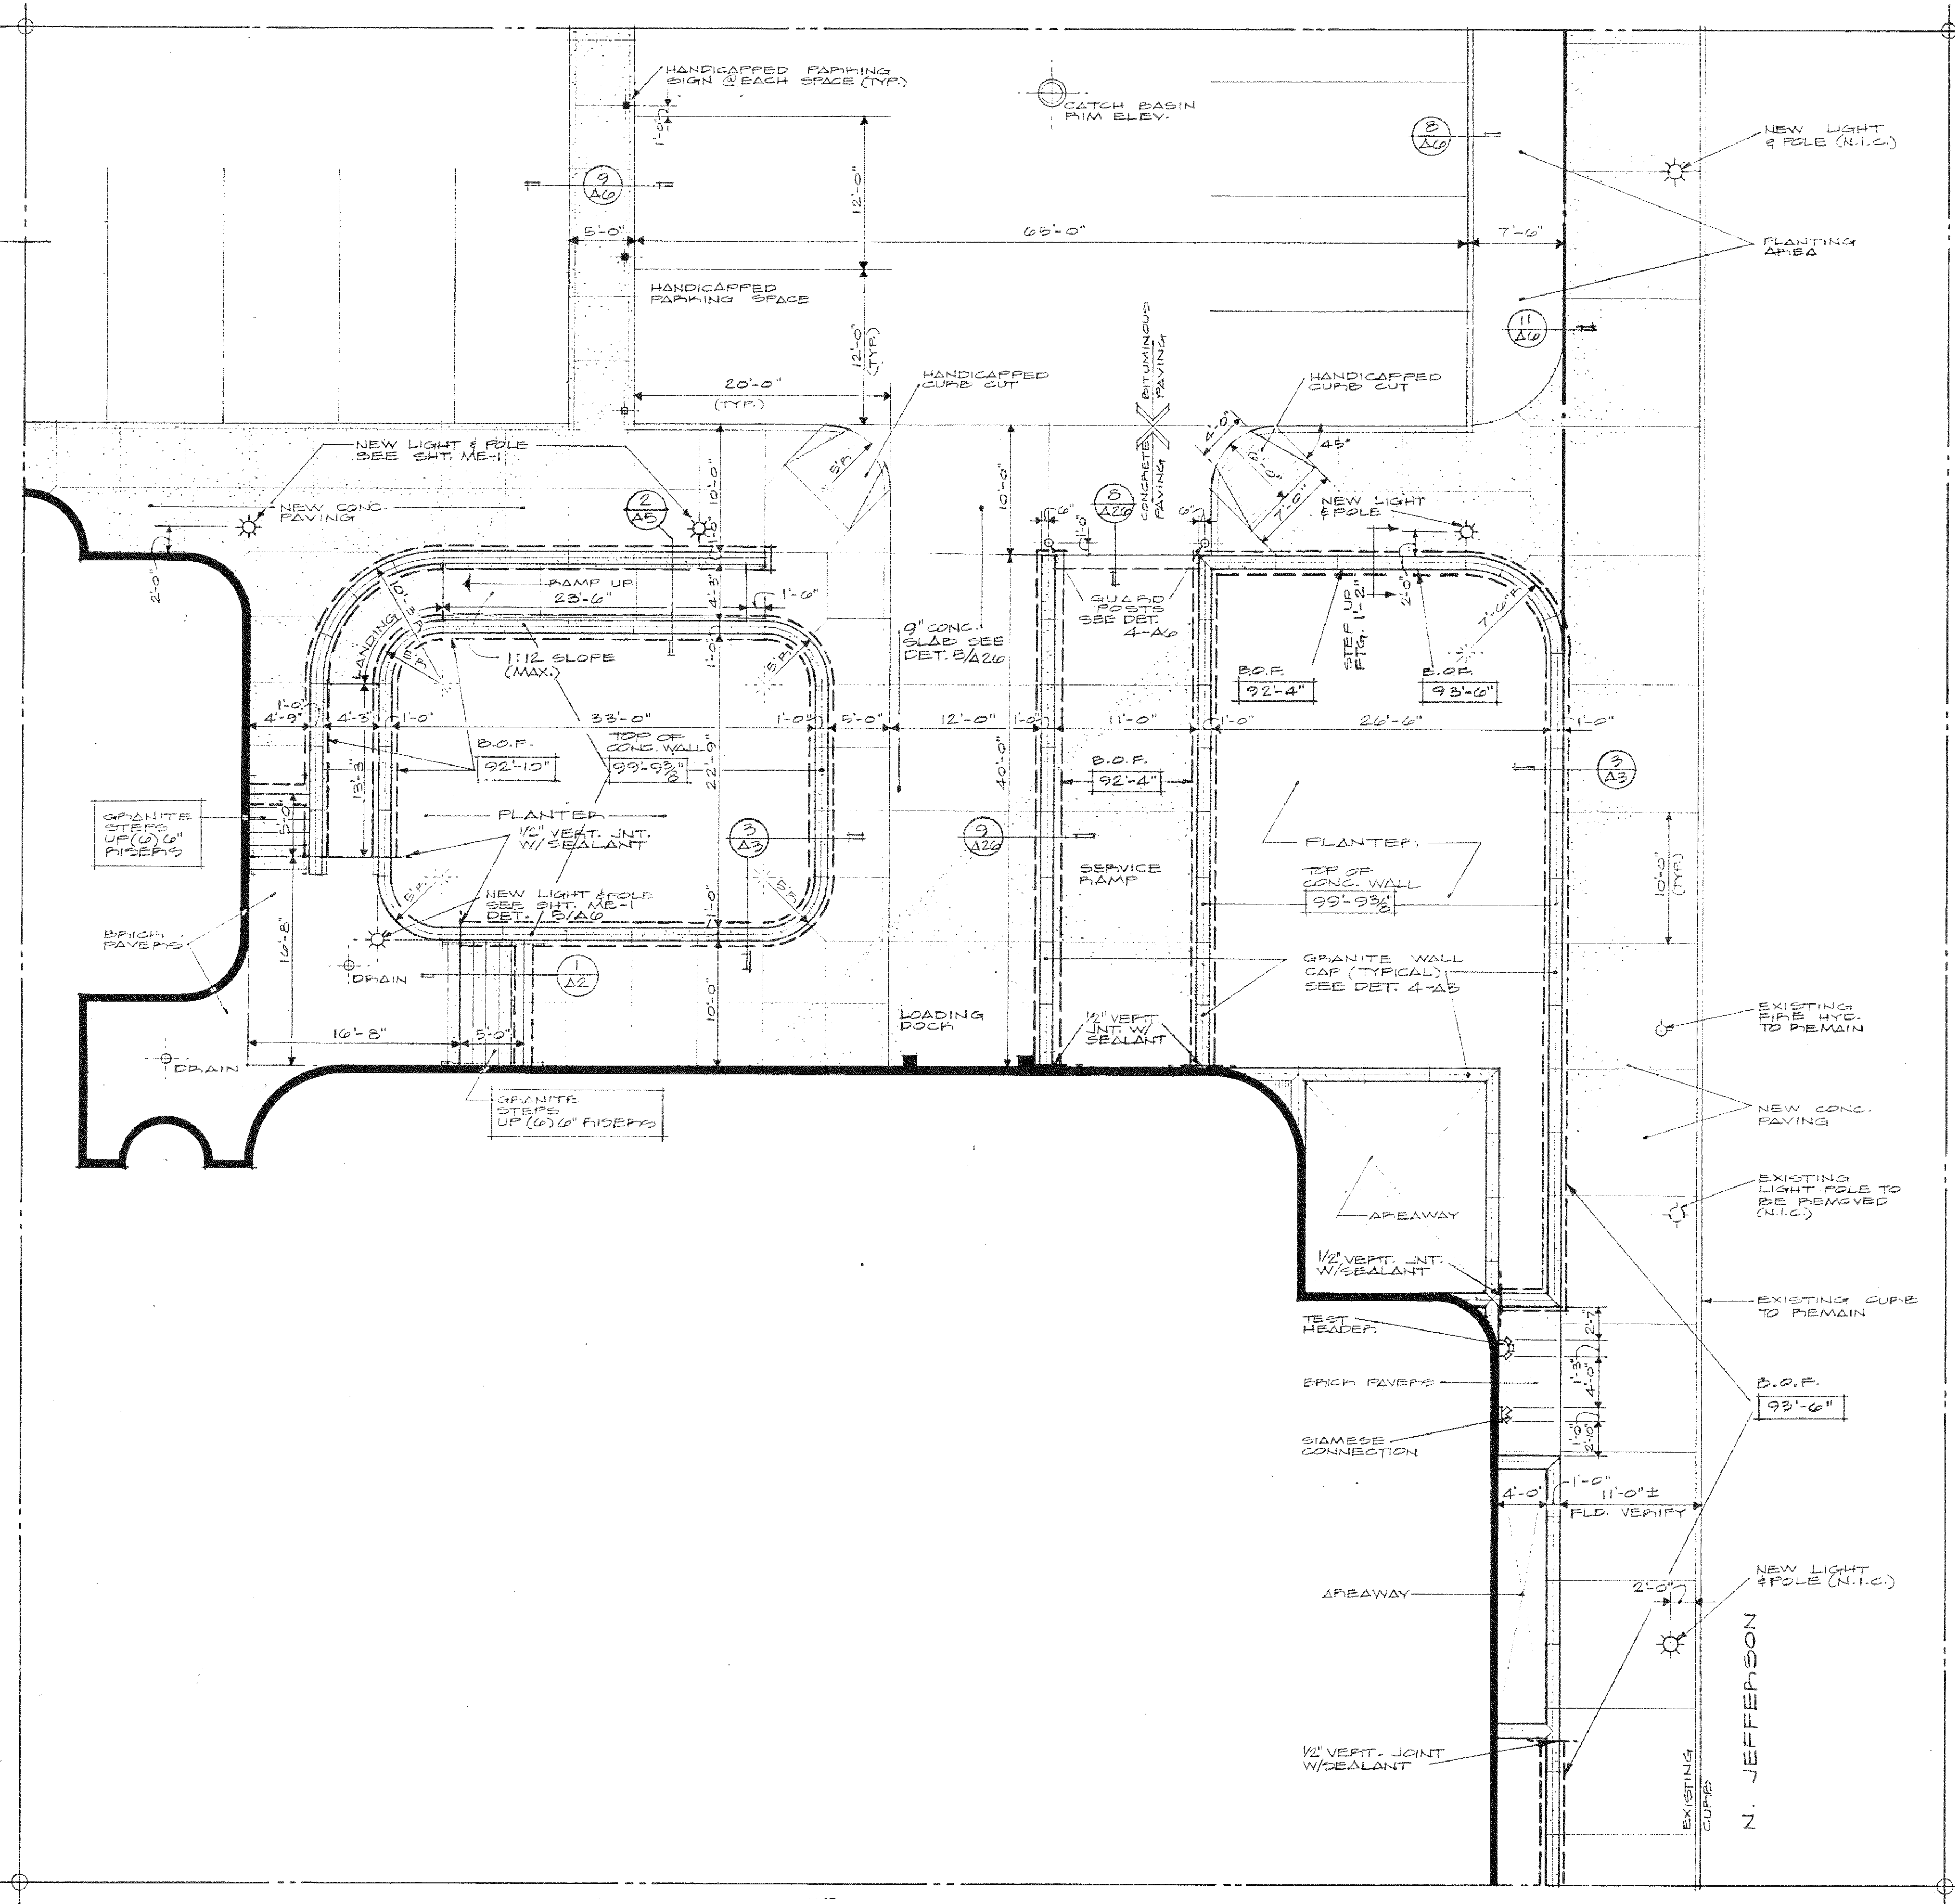


QUADRANT #4
SITE PLAN
SCALE: 1/8" = 1'-0"


SCALE: $1/2" = 1'-0"$

NOTES:

- 1) SEE SHEET A-1 FOR PROP. DIMENSIONS & EXISTING/FINISH GRADES ALSO QUADRANT LAYOUT.
- 2) PAVING LAYOUT IS BASED ON A 5'-0" X 5'-0" FT. GRID.
- 3) B.O.F. = BOTTOM OF FOOTING

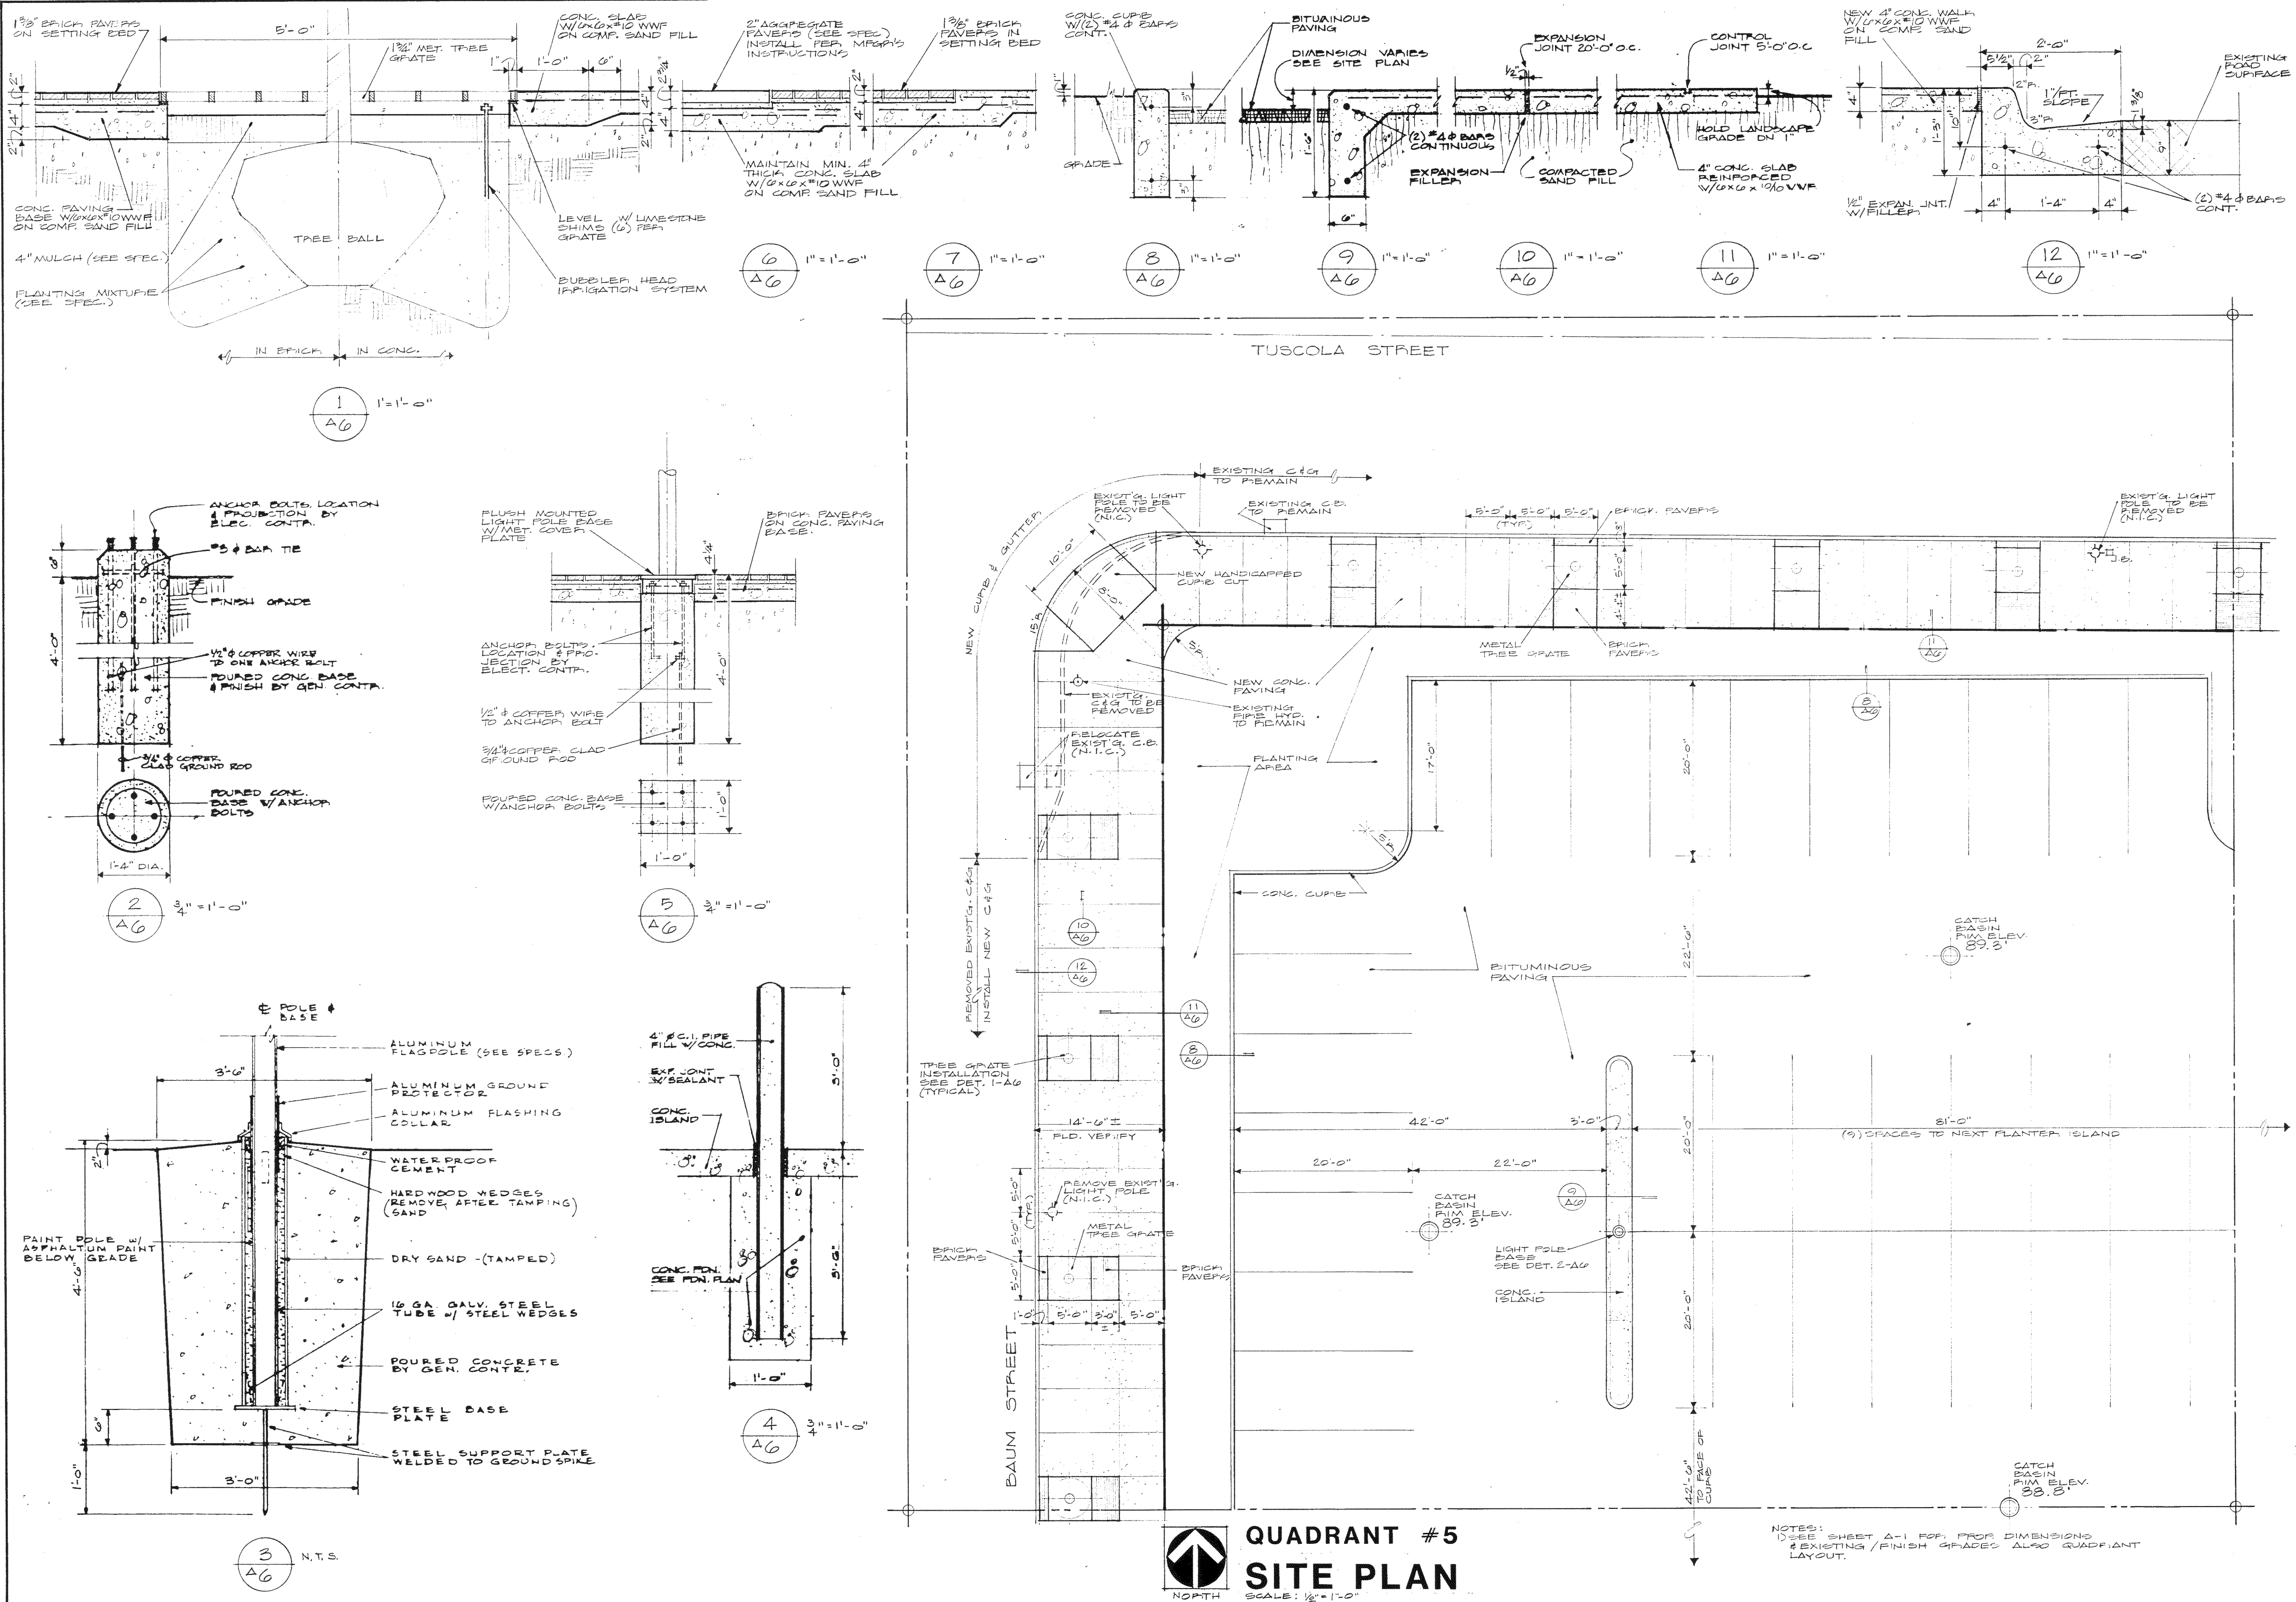

TUSCOLA

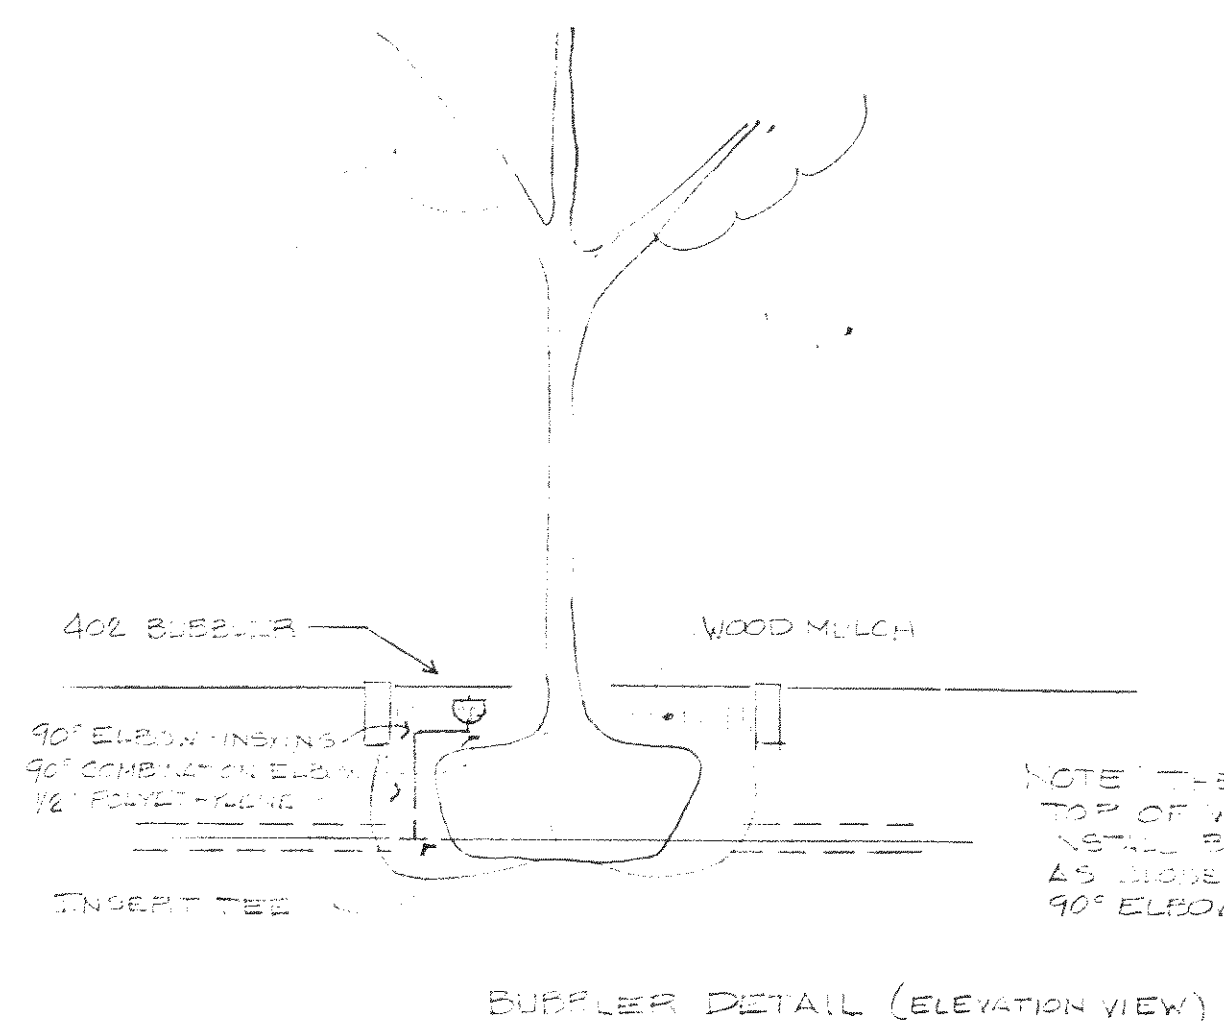



NOTE: THERE SHOULD BE CLEARANCE BTRY
TOP OF WOOD MUNCH • FREE C/PATE COVER
ASTLE BARRIER 1/2" ABOVE WOOD GRADE &
AS HIGH TO BASE OF TREE AS POSSIBLE FOR
90° ELBOWS & NECESSARY

IRRIGATION LEGEND

- IRRIGATION ELEVATION 4095
- ① BUCKNER/ROYAL COACH 4095 5/8" BUBBLER ON 1/2" CORNER BUSH STANDARD NOZZLE
- ② BUCKNER/ROYAL COACH 4095 5/8" BUBBLER ON 1/2" CORNER BUSH 5/8" NOZZLE
- ③ BUCKNER/ROYAL COACH 55' 50" ON NELSON 1/4" PORT SPRINKLER ON 1/2" CORNER BUSH 5/8" NOZZLE @ 150' 9/64" NOZZLE @ 90'
- ④ NELSON 4260 6" POP UP SPRAY (GROUND COVER)
W/ 740 SERIES NOZZLES
⑤ 1/1015 4" 1015 SERIES NOZZLES
- ⑥ NELSON 4240 4" POP UP LAWN SPRAY W/ 740 SERIES NOZZLES (LAWN)
- ⑦ NELSON 4270 2" POP UP SPRAY W/ 6010 BUBBLER, UMBRELLA SPRAY (SHADE)
- ⑧ BUCKNER/ROYAL COACH 402 BUBBLER 1" APPROX 3/4" TAP NOZZLE 126PM
- ⑨ BUCKNER/ROYAL COACH SR QUICK COUPLING VALVE
- ⑩ BUCKNER/ROYAL COACH 9604E SERIES AUTOMATIC CONTROL VALVE
- ⑪ VALVE STATION 1/4" ON CONTROLLER
VALVE SIZE
- 1/4" PIPE 1/4" NPT SLEEVE - SEE NOTE

BRIGADON NOTES

ALL MAINLINE PIPE TO BE 160 PSI PVC
ALL LATERAL PIPE TO BE 80 PSI POLYETHYLENE, NSF-APPROVED
ALL WIRE TO BE #40S CLAMPED TO CONCRETE SLAB
PROVIDE OWNER W/ THREE COPIES OF HOMEOWNERS
SPECS TO BE INSTALLED PRIOR TO POURING 18" BURY, 160 PSI PVC, SIZE AS SHOWN @,
REFUND V.I. OF GENERAL CONTRACTOR
OWNER IS TO ASSIGN INSUR W/ THE ARCHITECTURAL DRAWINGS PAYING PARTICULAR
ATTENTION TO PLANTER CONCRETE ON GRABE CHANGES

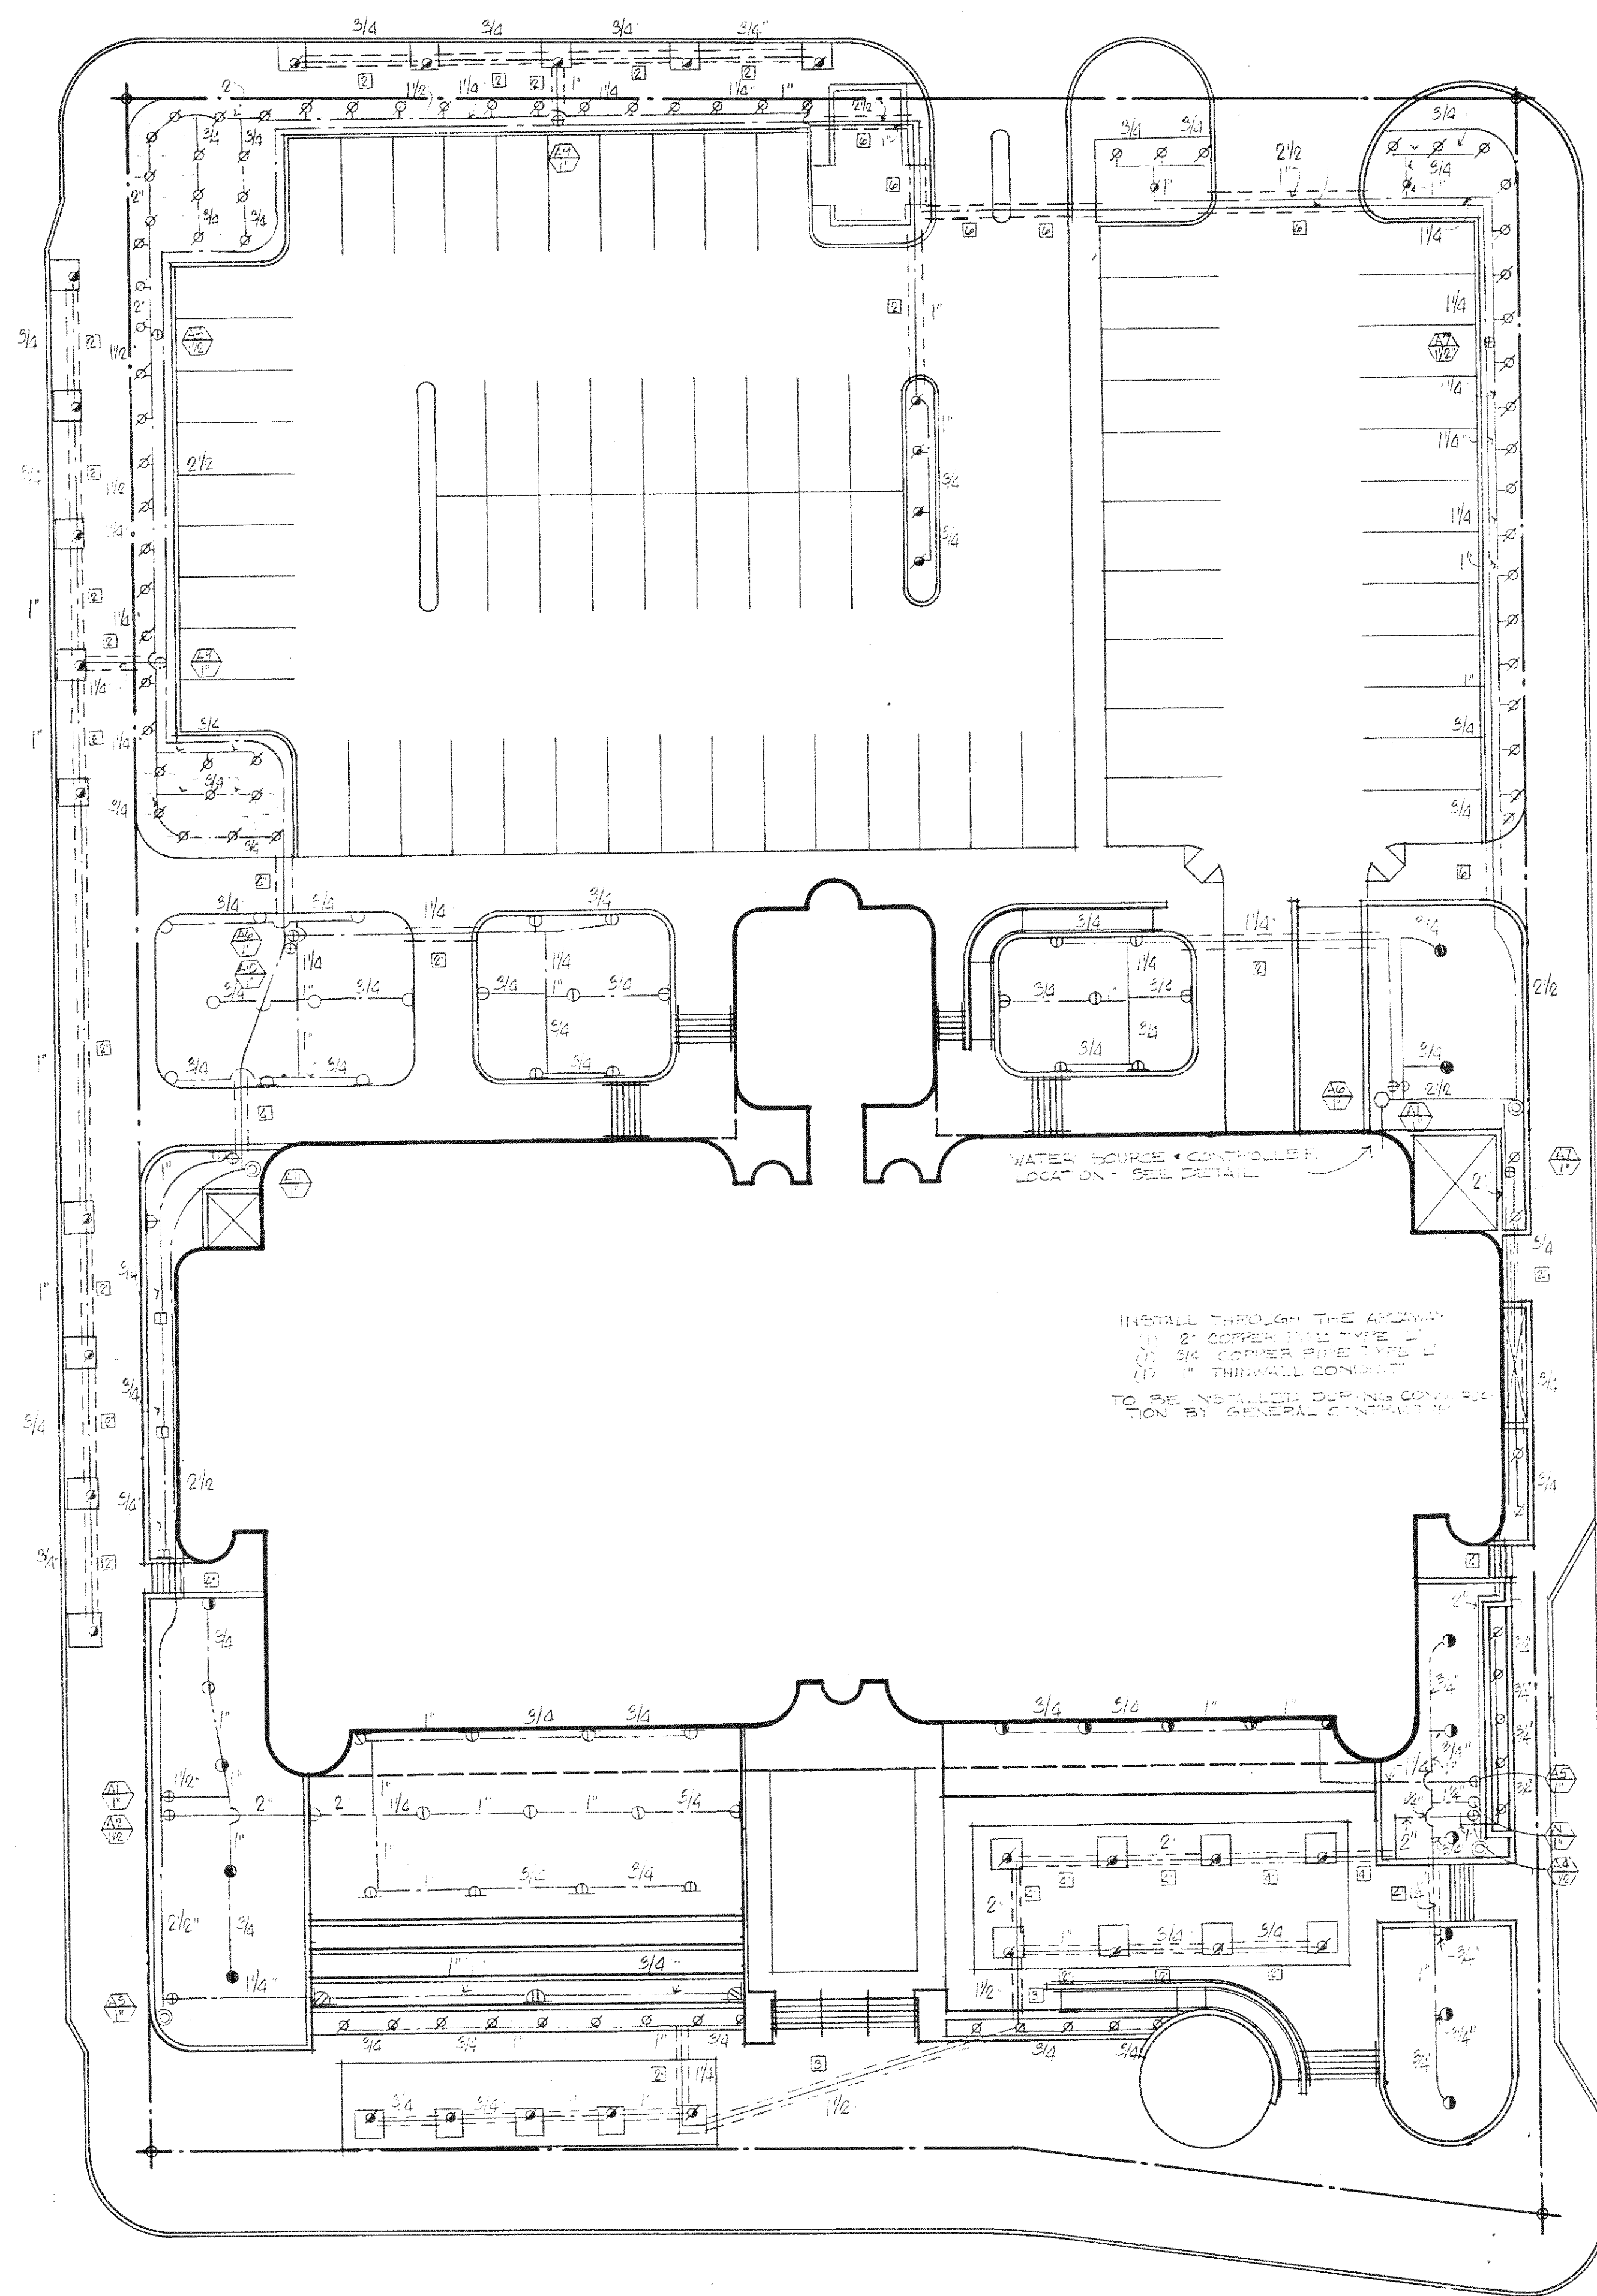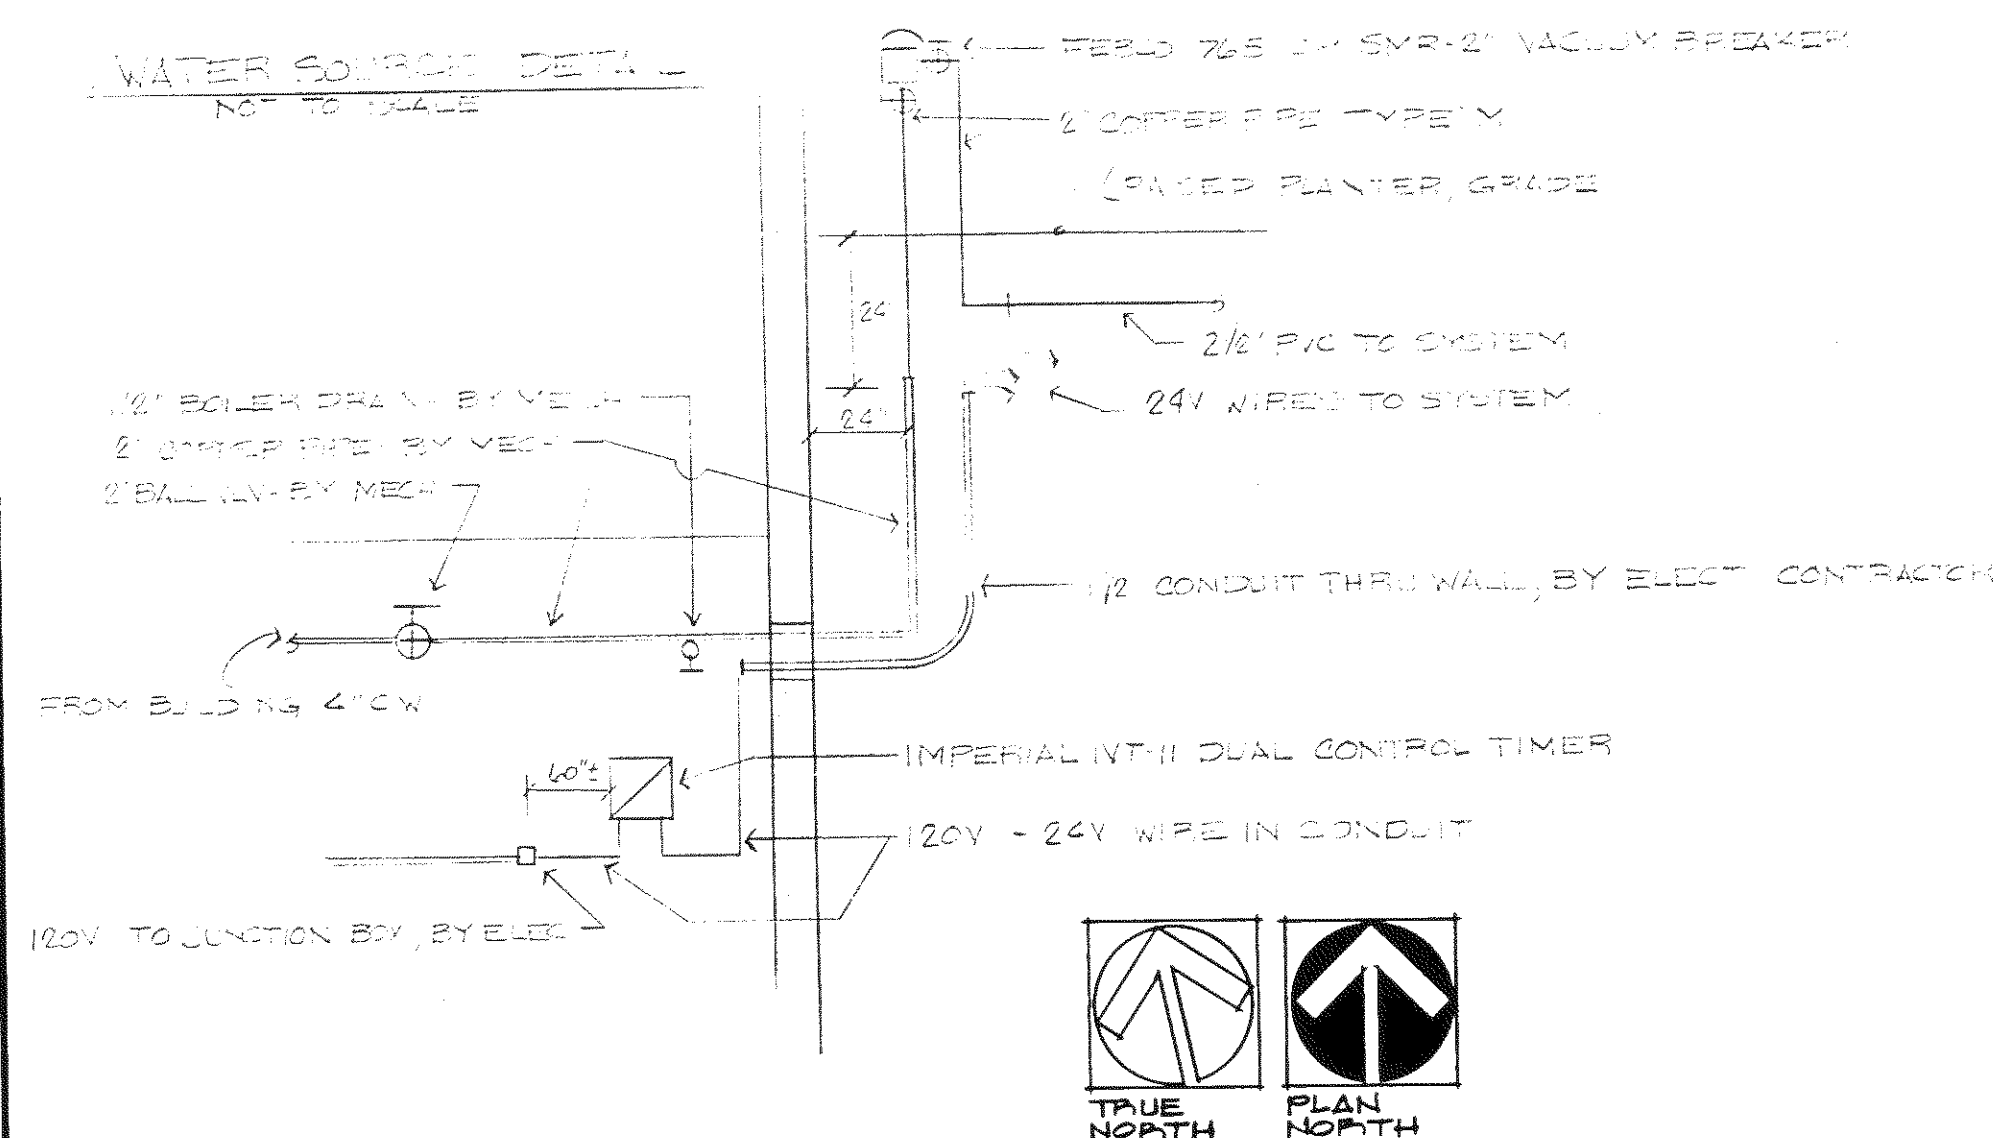

INSTALL THROUGH THE AIRWAY

- (A) 2" COPPER PIPE TYPE L
- (B) 3/4" COPPER PIPE TYPE L
- (C) 1" THINWALL CONDUIT

TO BE INSTALLED USING CONDUIT
TENSION BY GRAVITY OR TENSIONING

E. GENESEE

IRRIGATION PLAN

SCALE: 1"=20'-0"

N. JEFFERSON

WGEN TINKNELL & ASSOCIATES, INC.
ARCHITECTS / PLANNERS

BECKETT, RAEDER, RANKIN, INC.
LANDSCAPE ARCHITECTS

STATE OF MICHIGAN
STATE OFFICE BUILDING
SAGINAW MICHIGAN


DESIGNED
DRAWN
CHECKED
APPROVED

DATE	AUG. 1980
------	--------------

ISSUED FOR	☐ PRELIMINARY	☒ CONSTRUCTION	☐ FINAL RECORD
------------	--------------------------------------	--	---------------------------------------

IDENTIFICATION NO.
PROJECT 7913
STATE ACCOUNT

SHEET	L2
-------	----

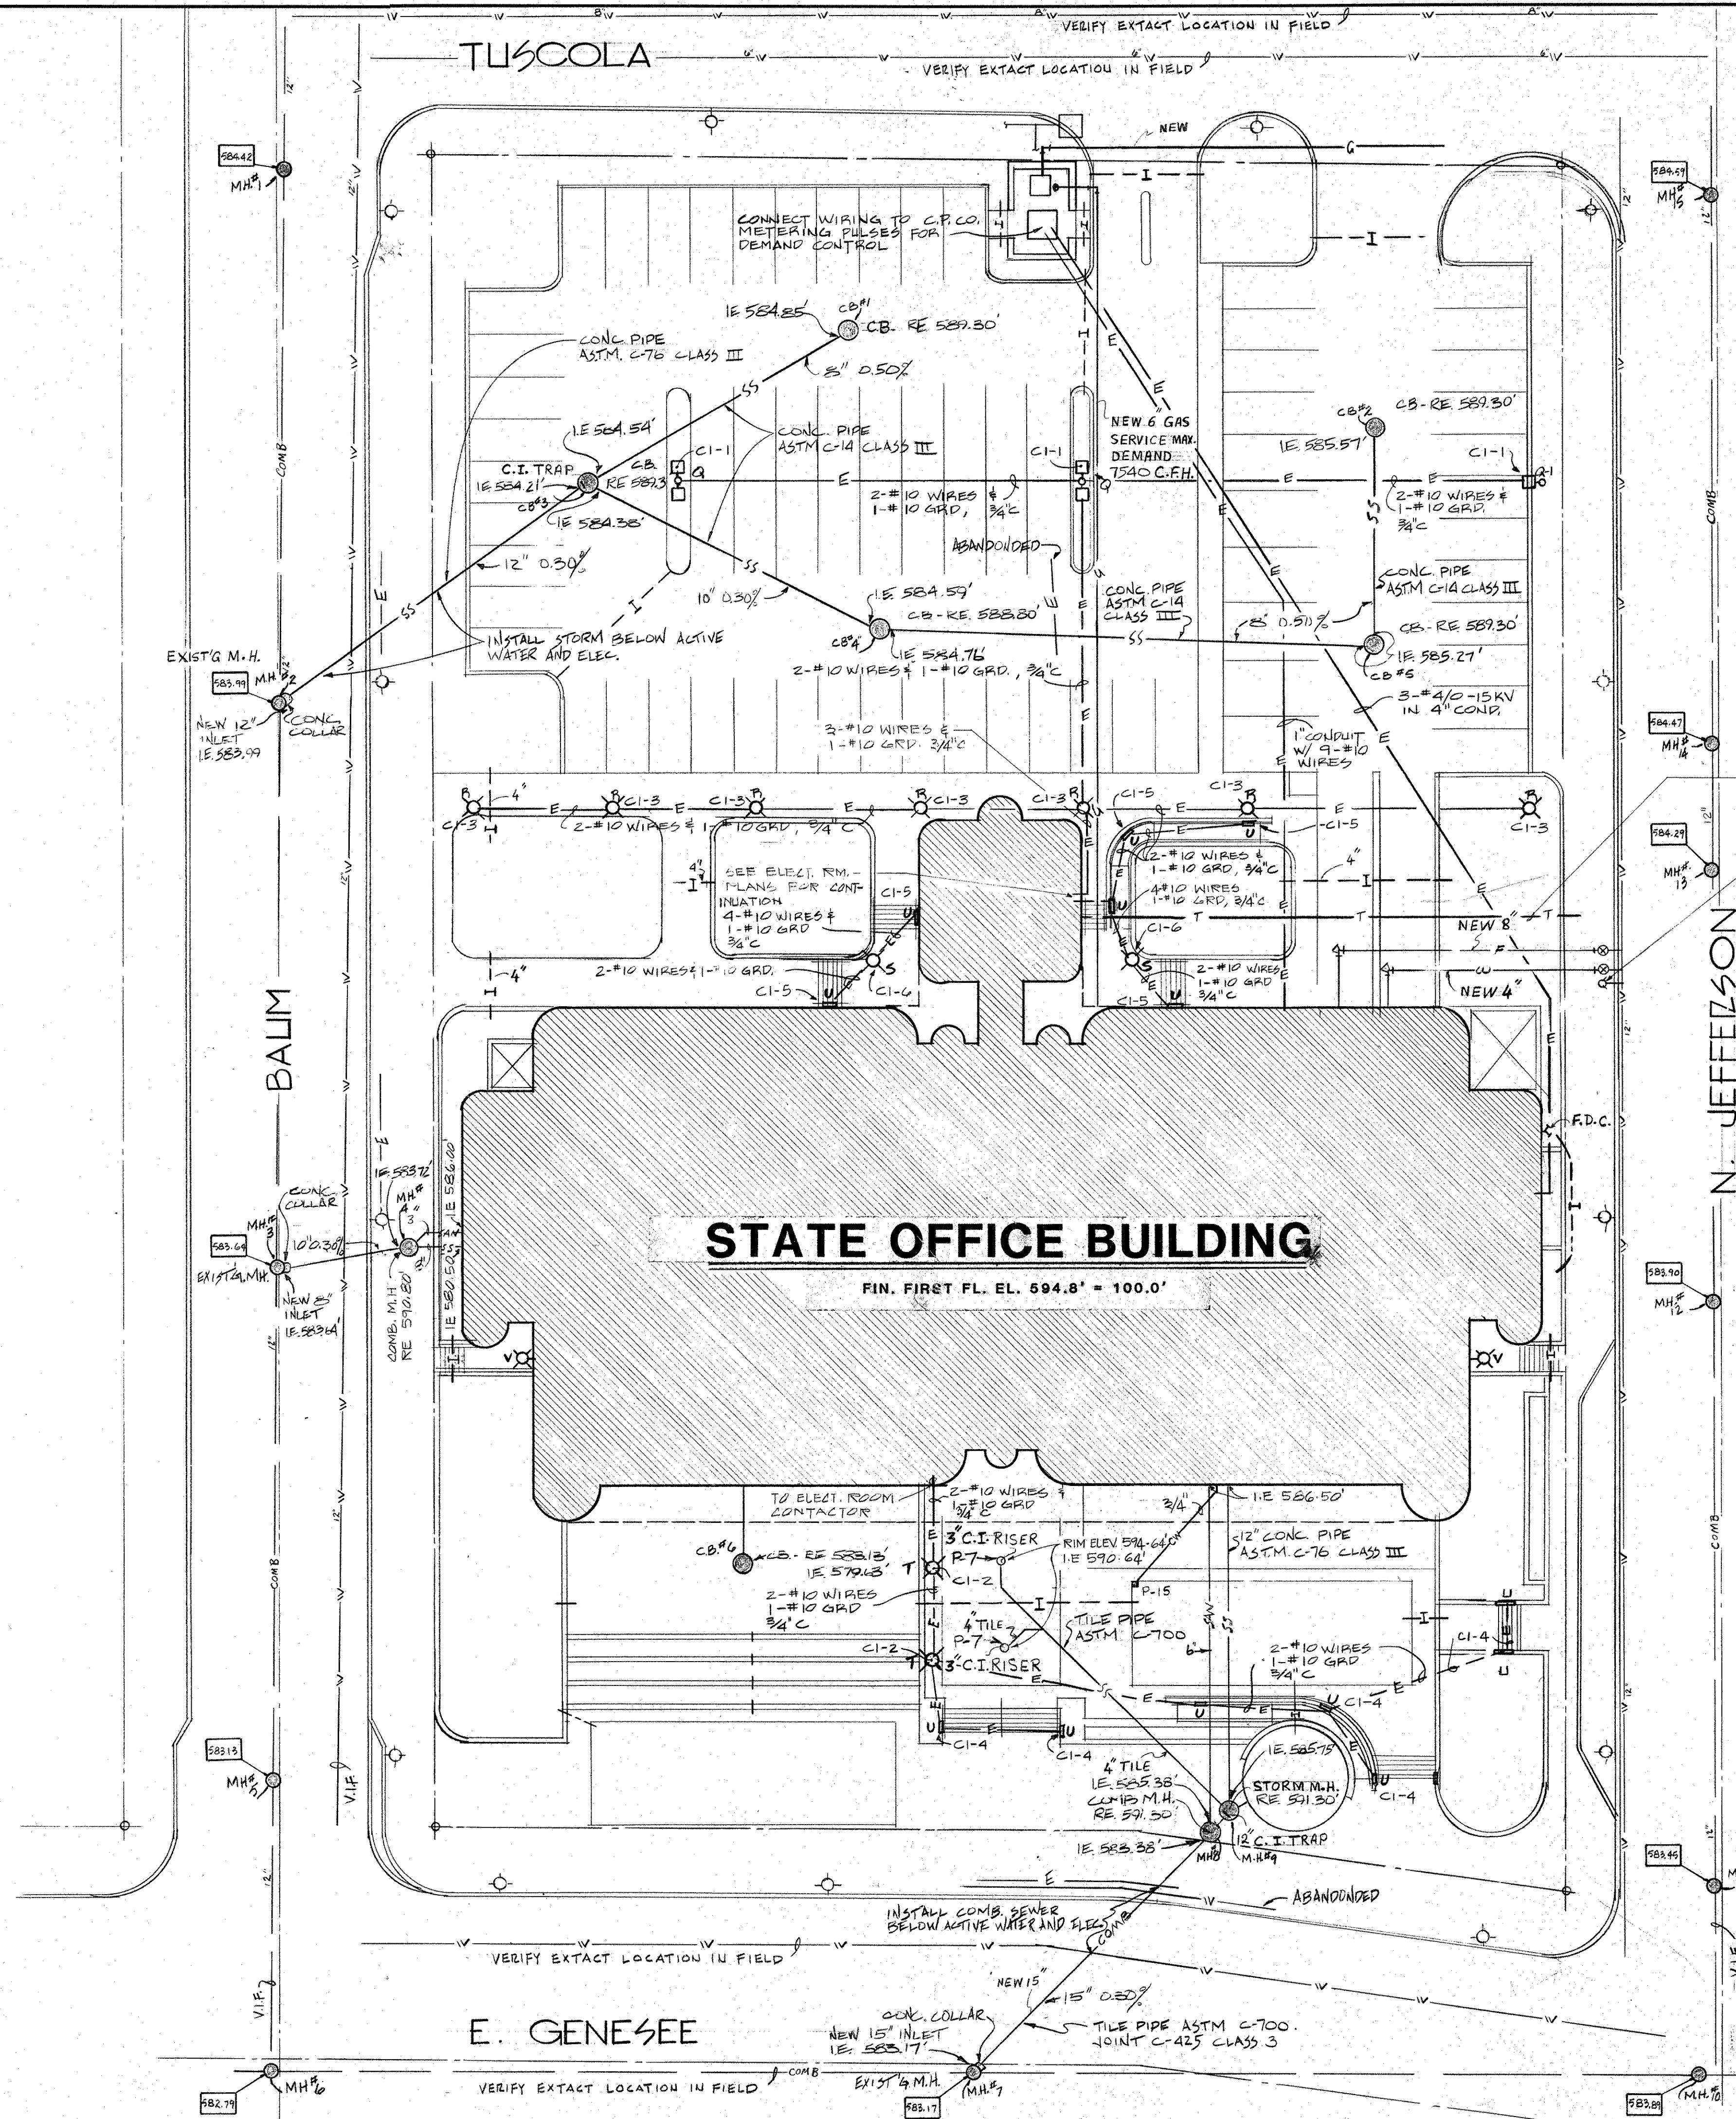

GENERAL NOTES:

1. FIELD VERIFY ALL ELEV. OF PIPES AND SEWERS BEFORE INSTALLING AND COMMENCING ANY WORK.
2. TILE AND CONC. PIPE JOINTS SHALL BE "PREMIUM" COMPRESSION TYPE.
3. TILE PIPE JOINTS A.S.T.M. C-425 CLASS 3.
4. CONC. PIPE JOINTS A.S.T.M. C-443 "O" RING.



SITE PLAN - MECHANICAL & ELECTRICAL

SCALE: 1"=20'0"